



10TH FLOOR FLOOR PLAN
SCALE: 1/8" = 1'-0"

10/5/10
NTS

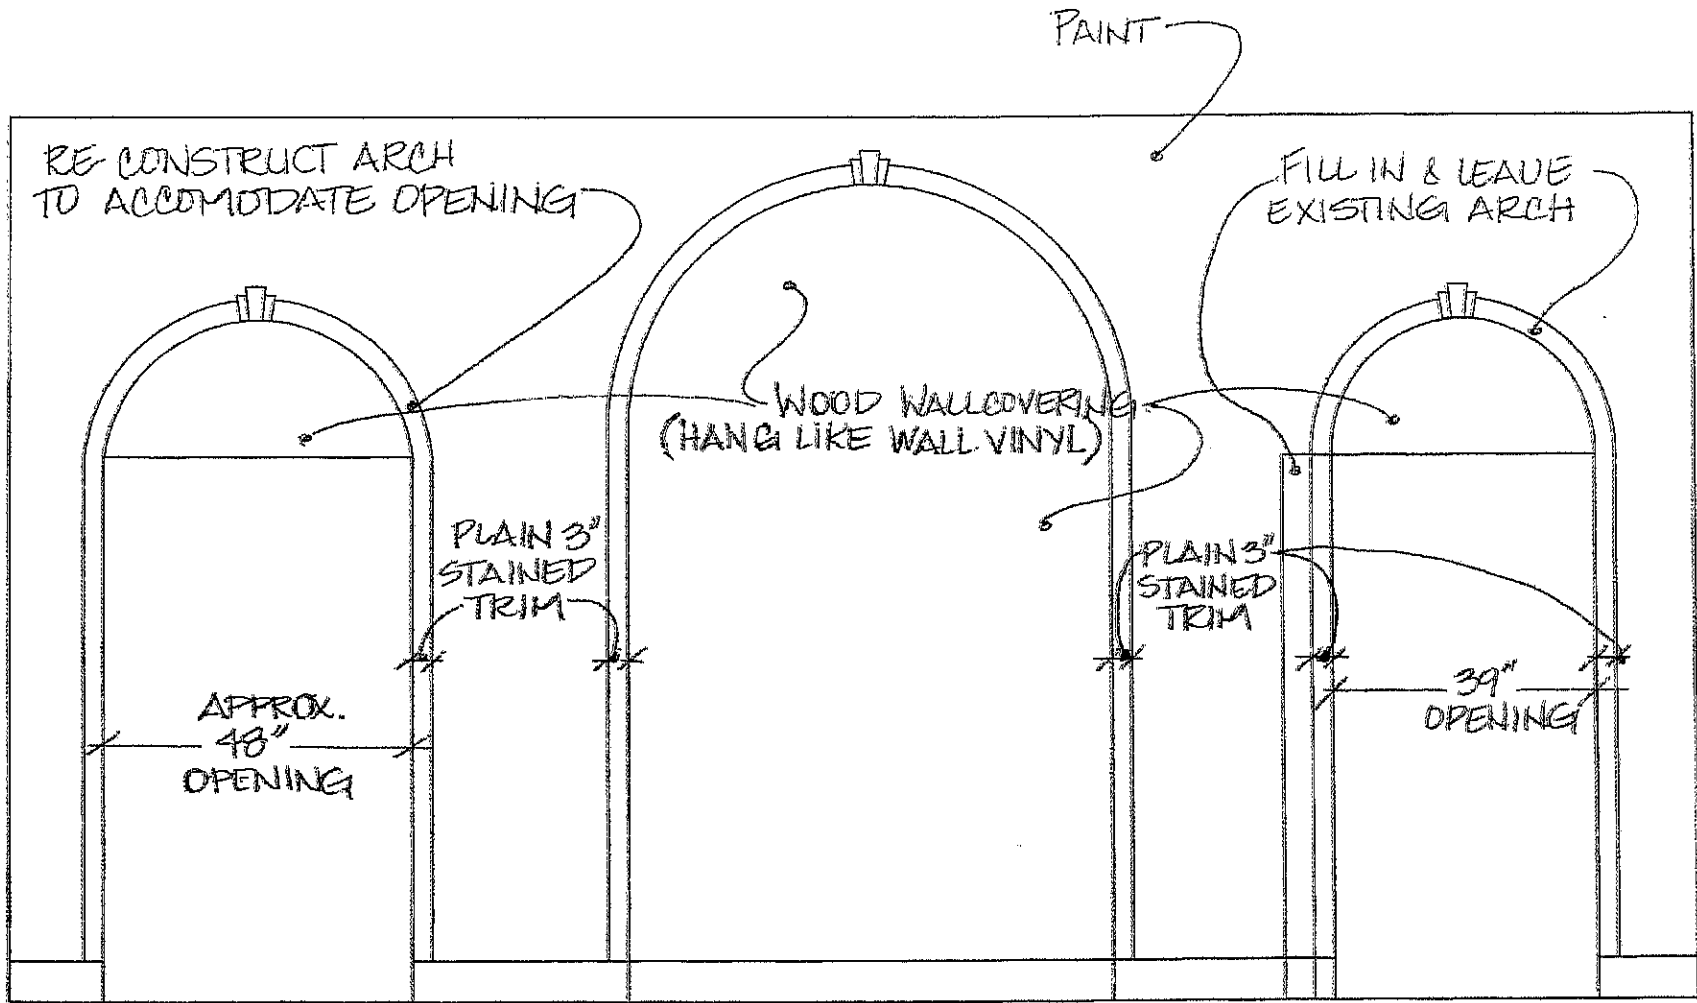


10TH FLOOR ELEVATION
 NTS

10/5/10
 NTS

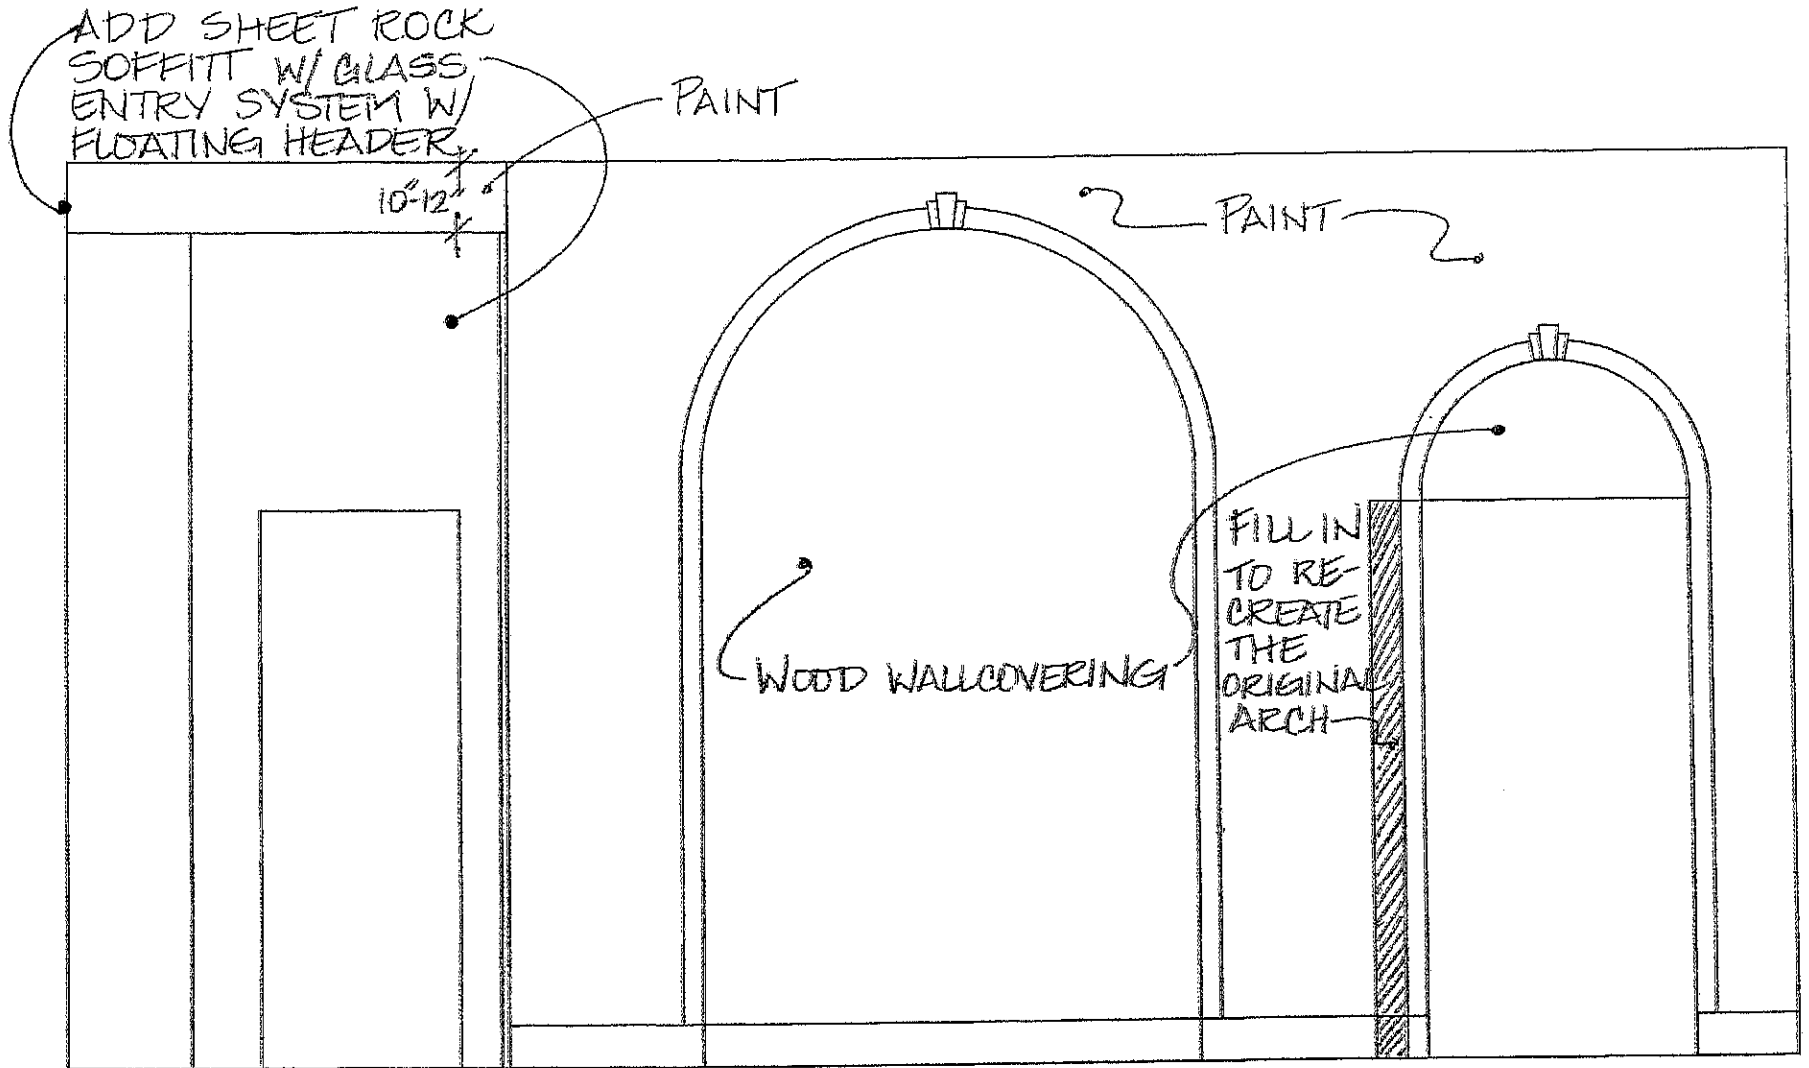

10TH FLOOR ELEVATION
 NTS


10/5/10
 NTS

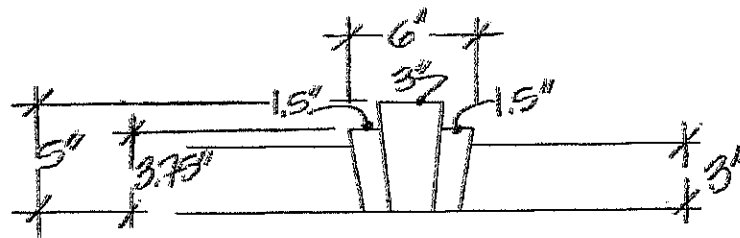


WINDOW MOULDING DETAIL
 SCALE: 1 1/2" = 1'-0"

STAINED TO MATCH:

10/5/10
 NTS

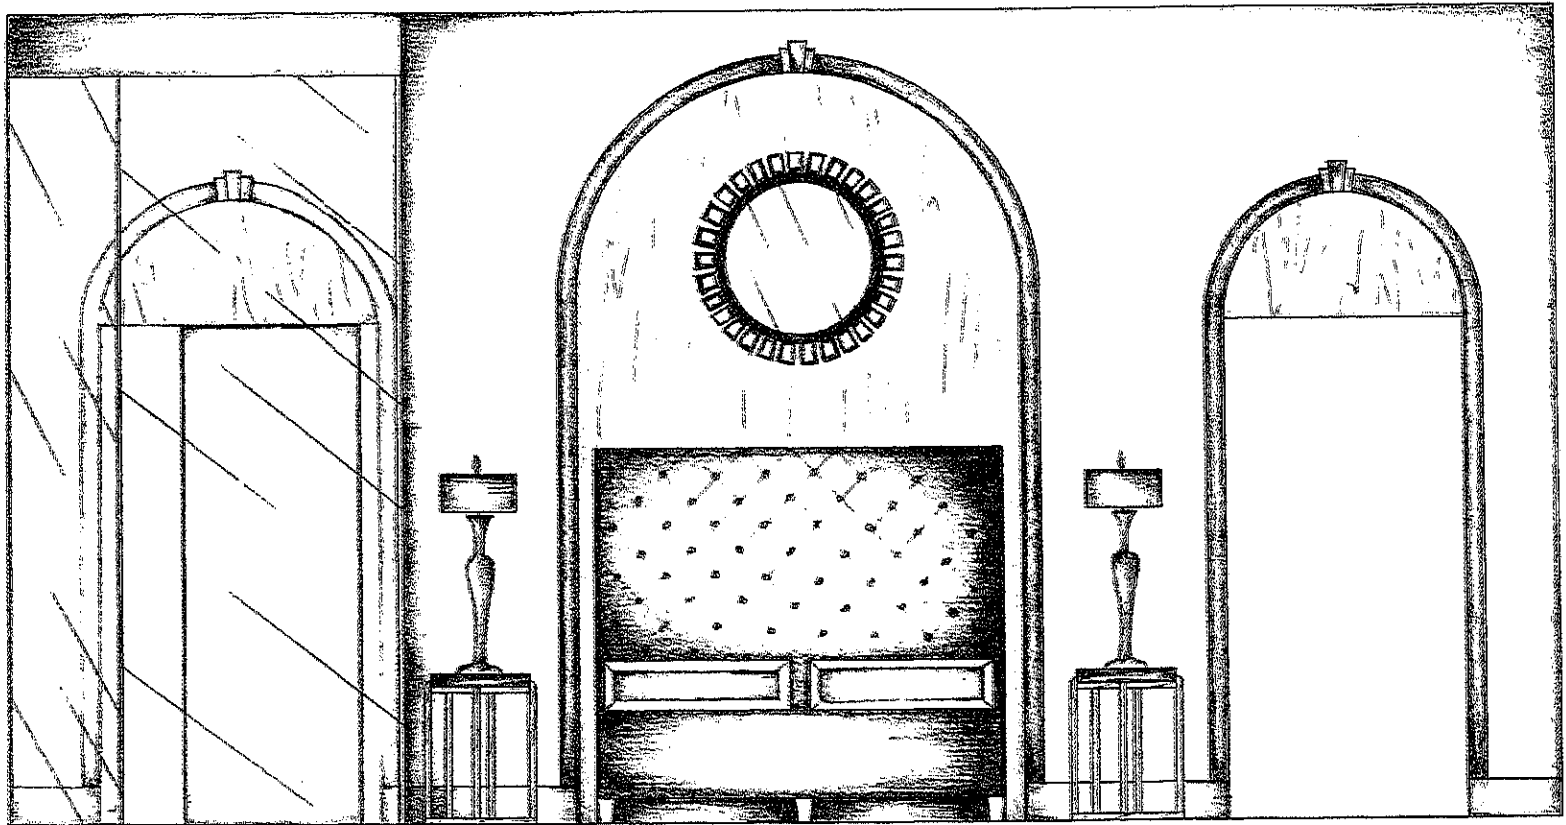


10TH FLOOR ELEVATION / BANQUETTE CONCEPT 10/5/10
NTS

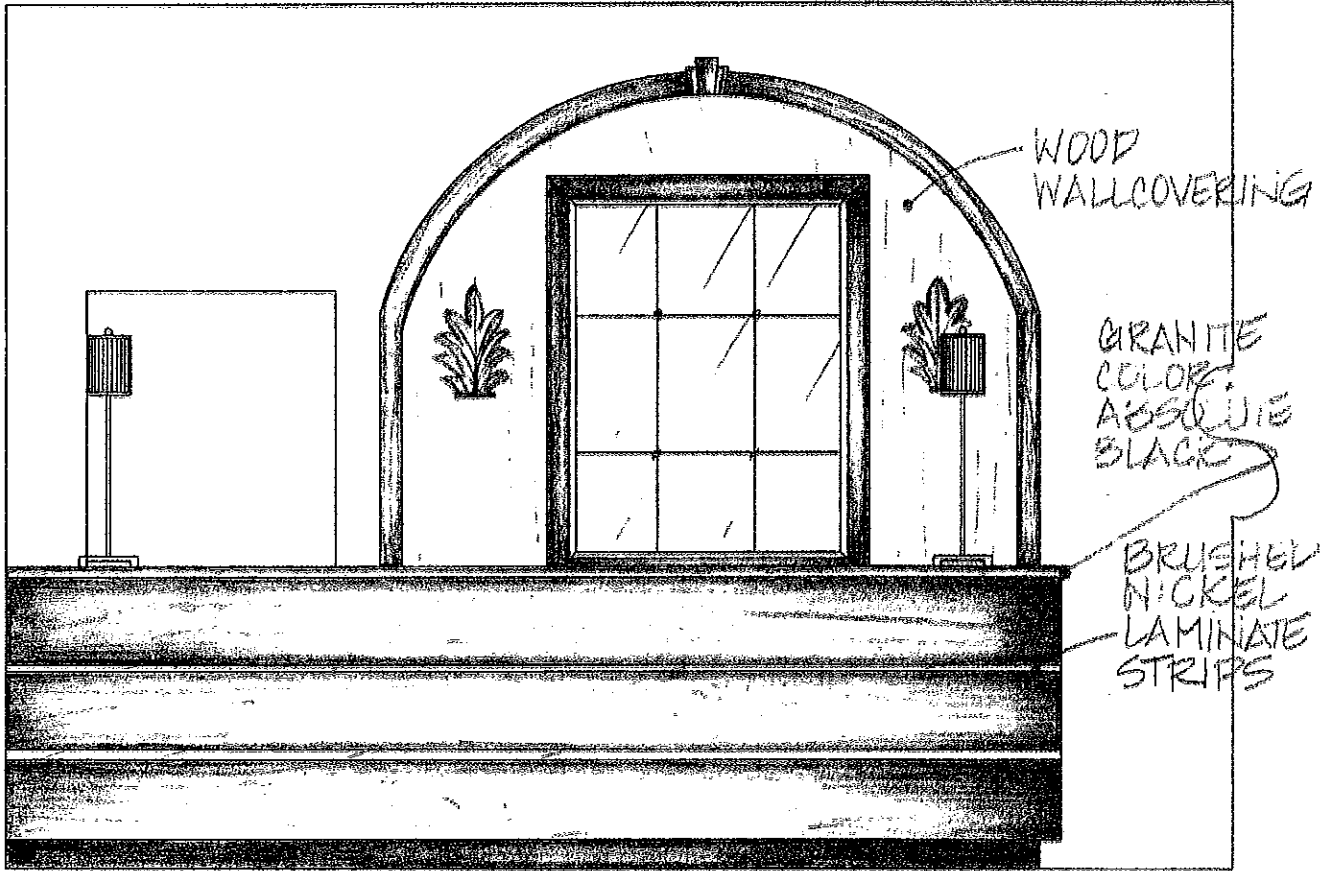

10TH FLOOR BAR
SCALE = 1/2" = 1'-0"

10/5/10
NTS

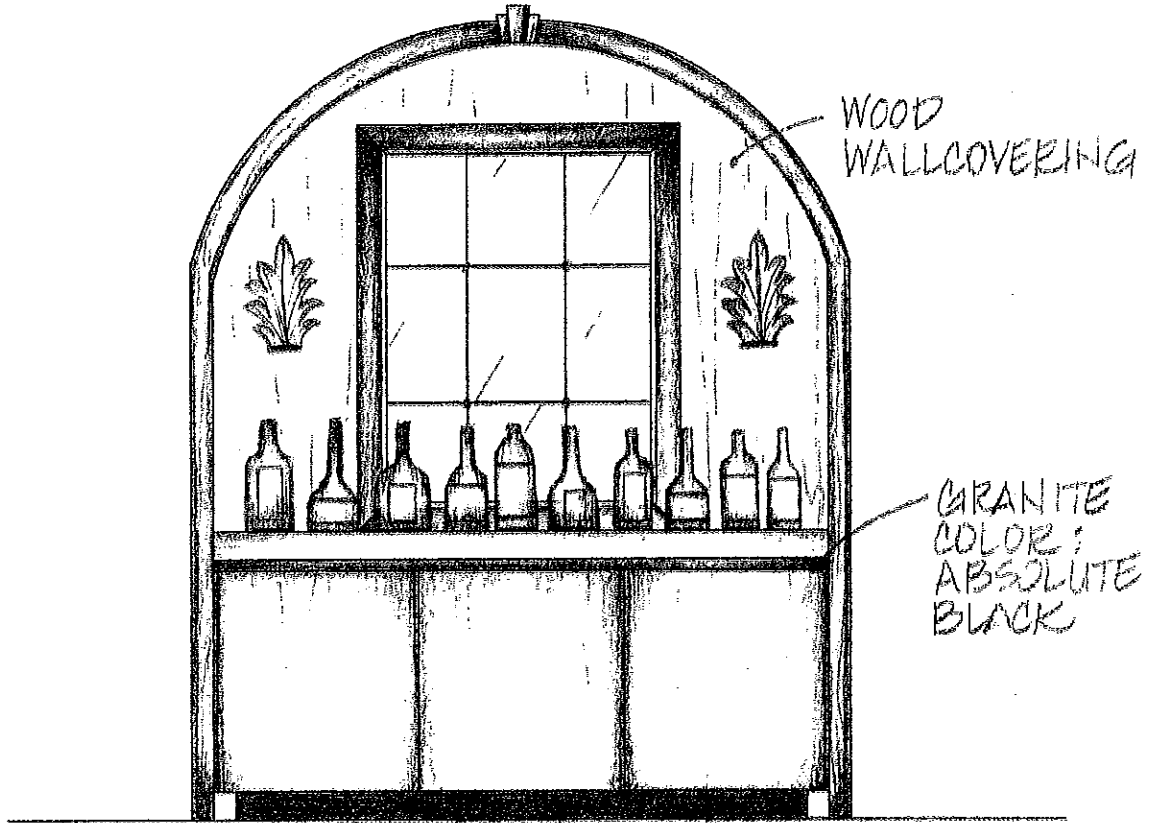


10TH FLOOR BACK BAR

SCALE: 1/2" = 1'-0"

10/5/10

NTS

ACCENT PAINT
THIS WALL

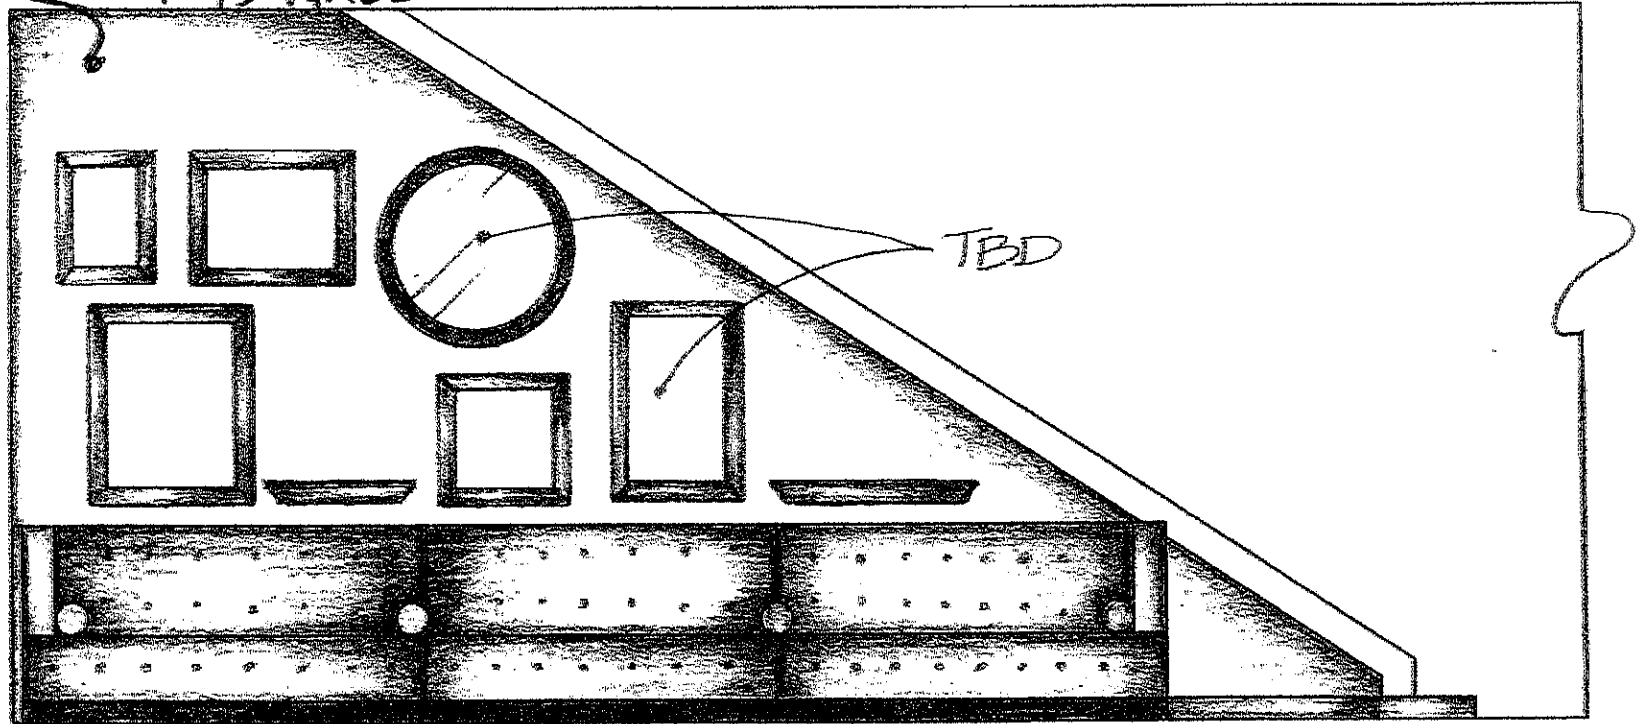


TBD

10TH FLOOR STAIRWALL ELEVATION

SCALE: 1/4" = 1' 0"

10/5/10


NTS

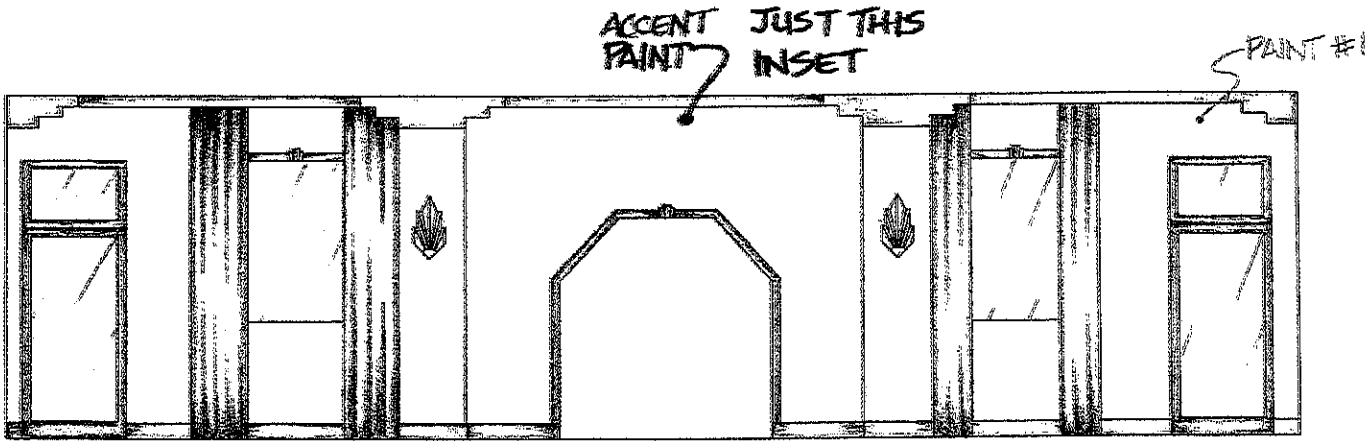


10TH FLOOR WINDOW WALL ELEVATION
SCALE: 1/4" = 1'-0"

10/5/10
NTS

NEW CONCEPT
WITHOUT AREA
OF REFUGE

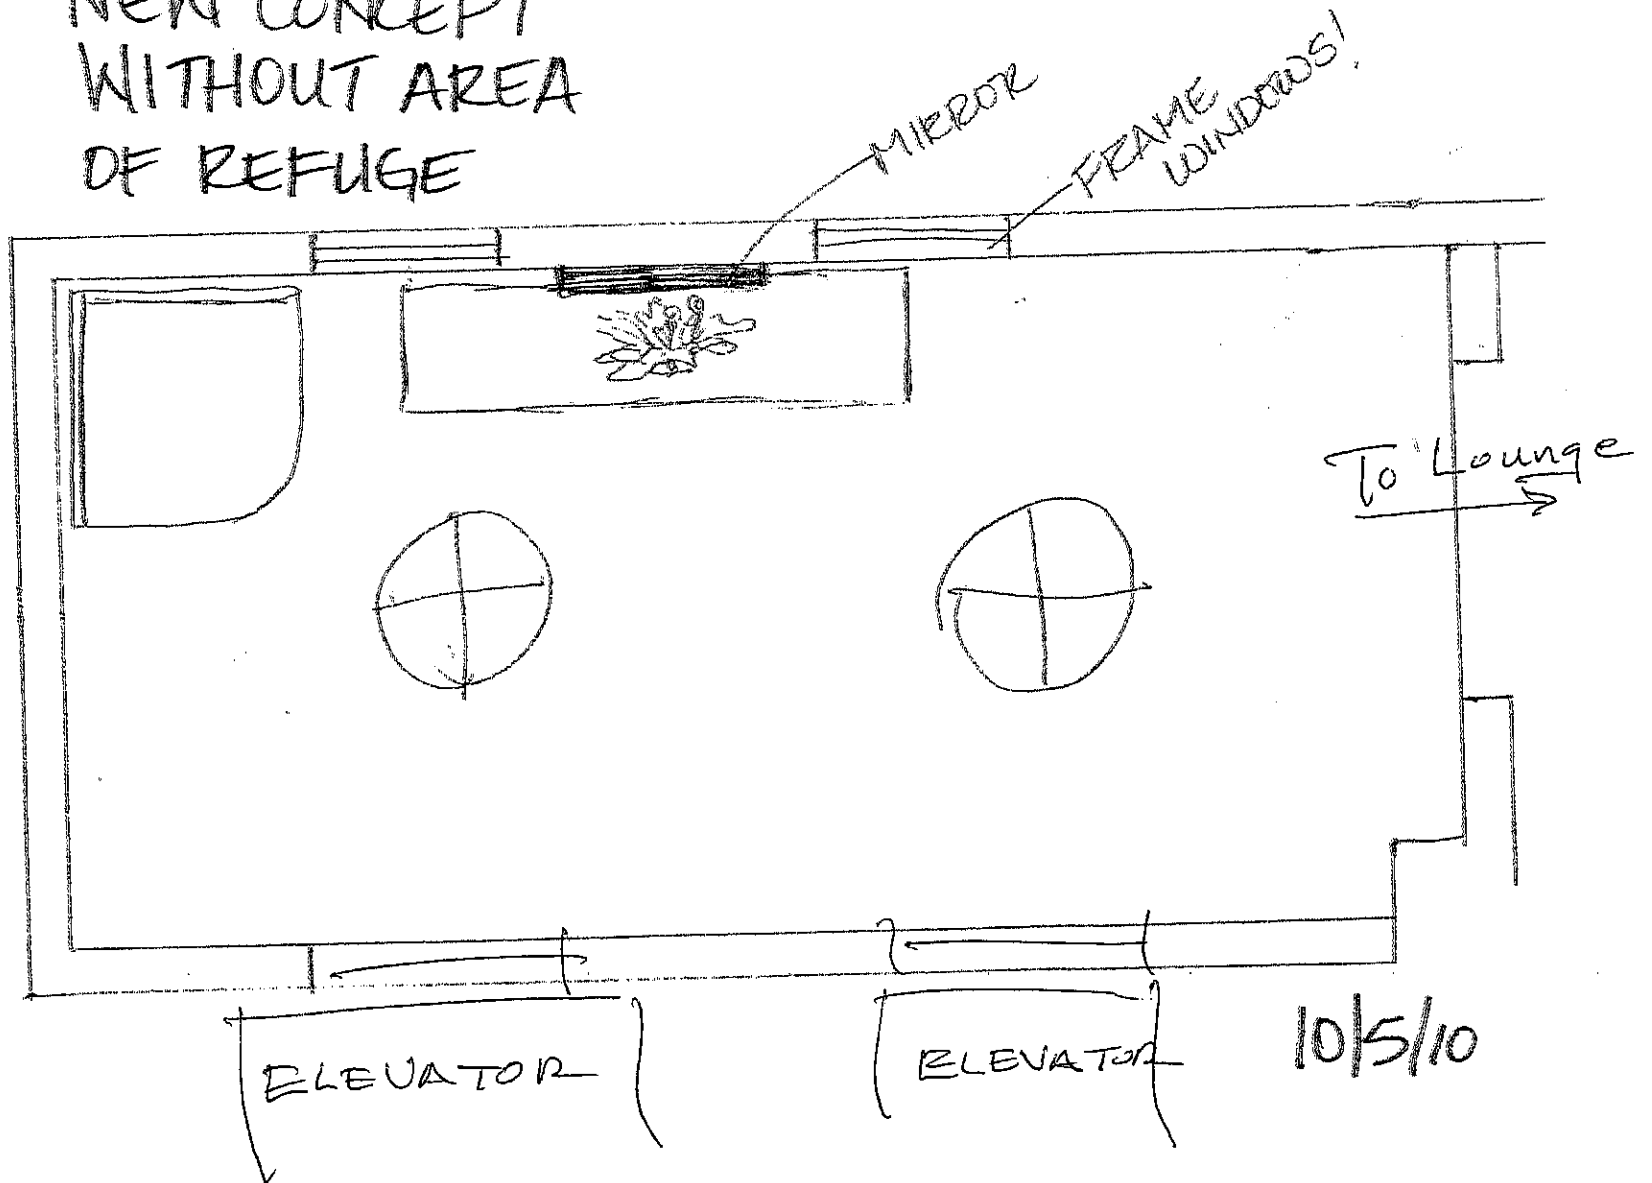

MIRROR

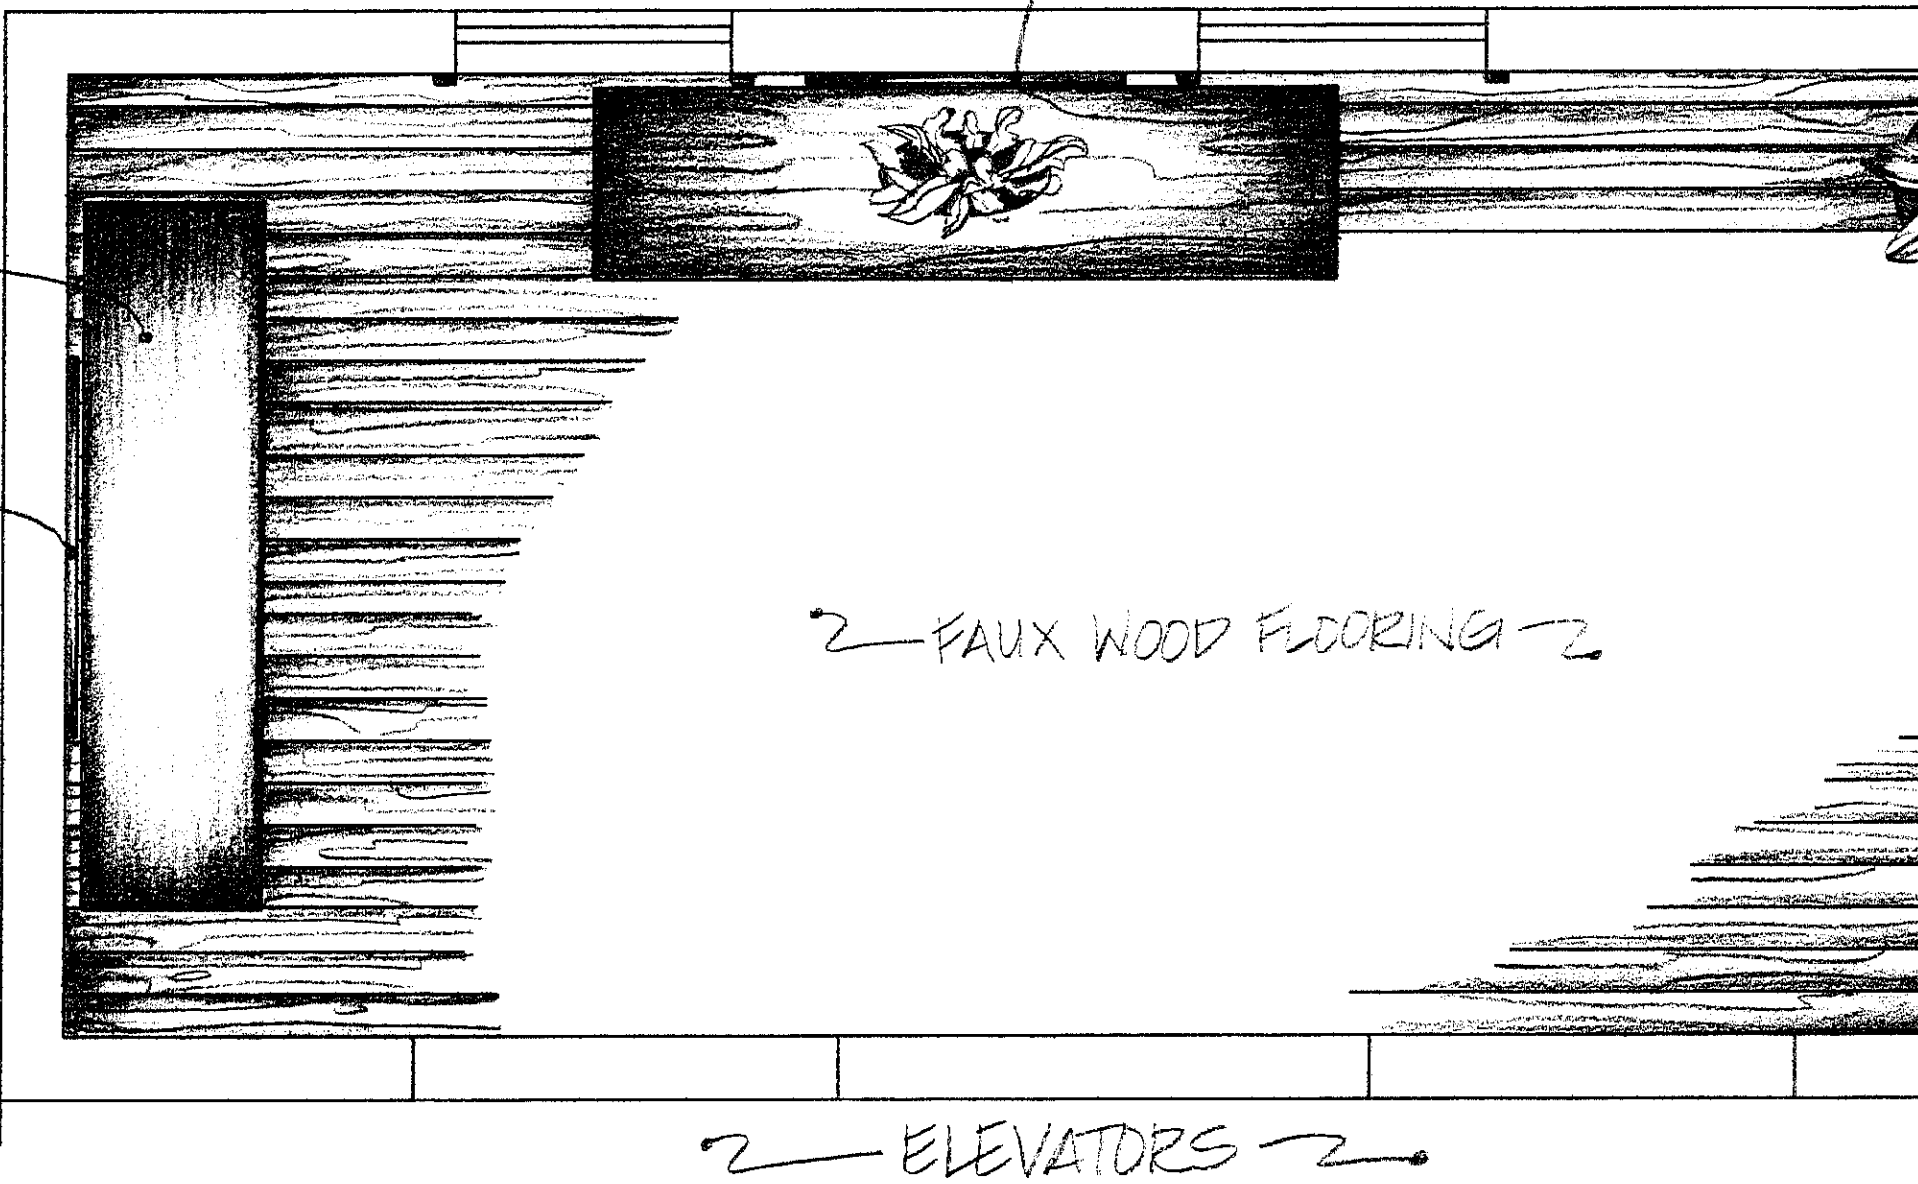


2 FAUX WOOD FLOORING 2

2 ELEVATORS 2

10TH FLOOR ELEVATOR FOYER

SCALE: 1/2" = 1'-0"

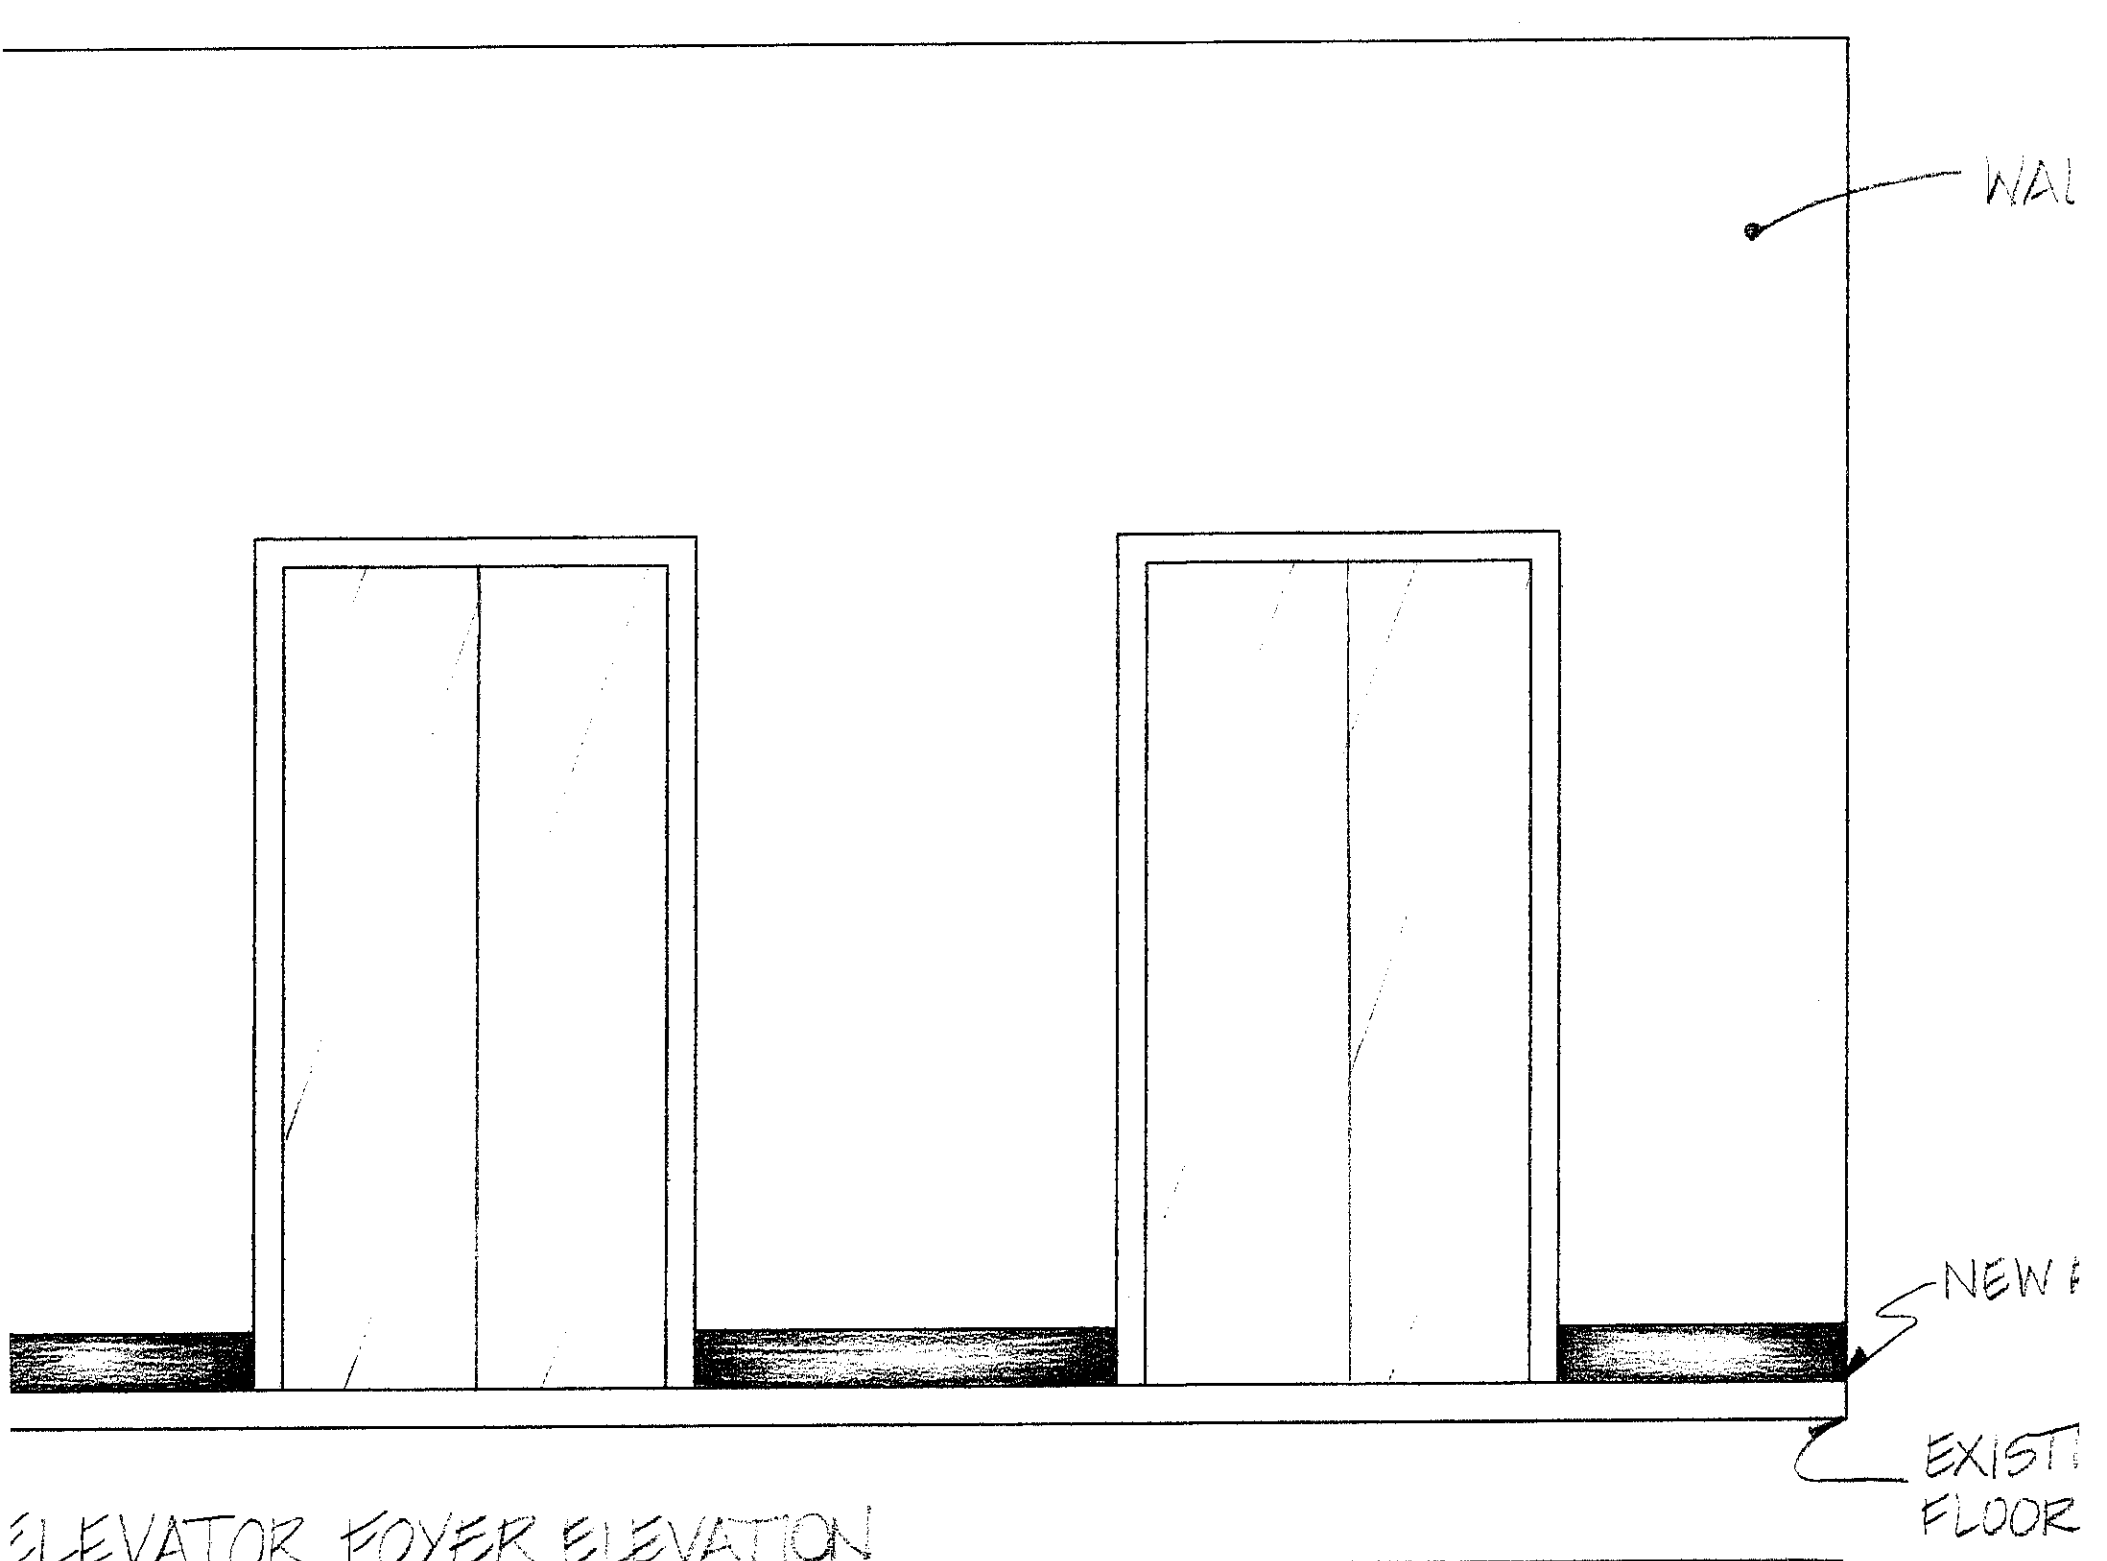


WAL

NEW F

EXIST.
FLOOR

ELEVATOR FOYER ELEVATION

SCALE: 1/2" = 1'-0"

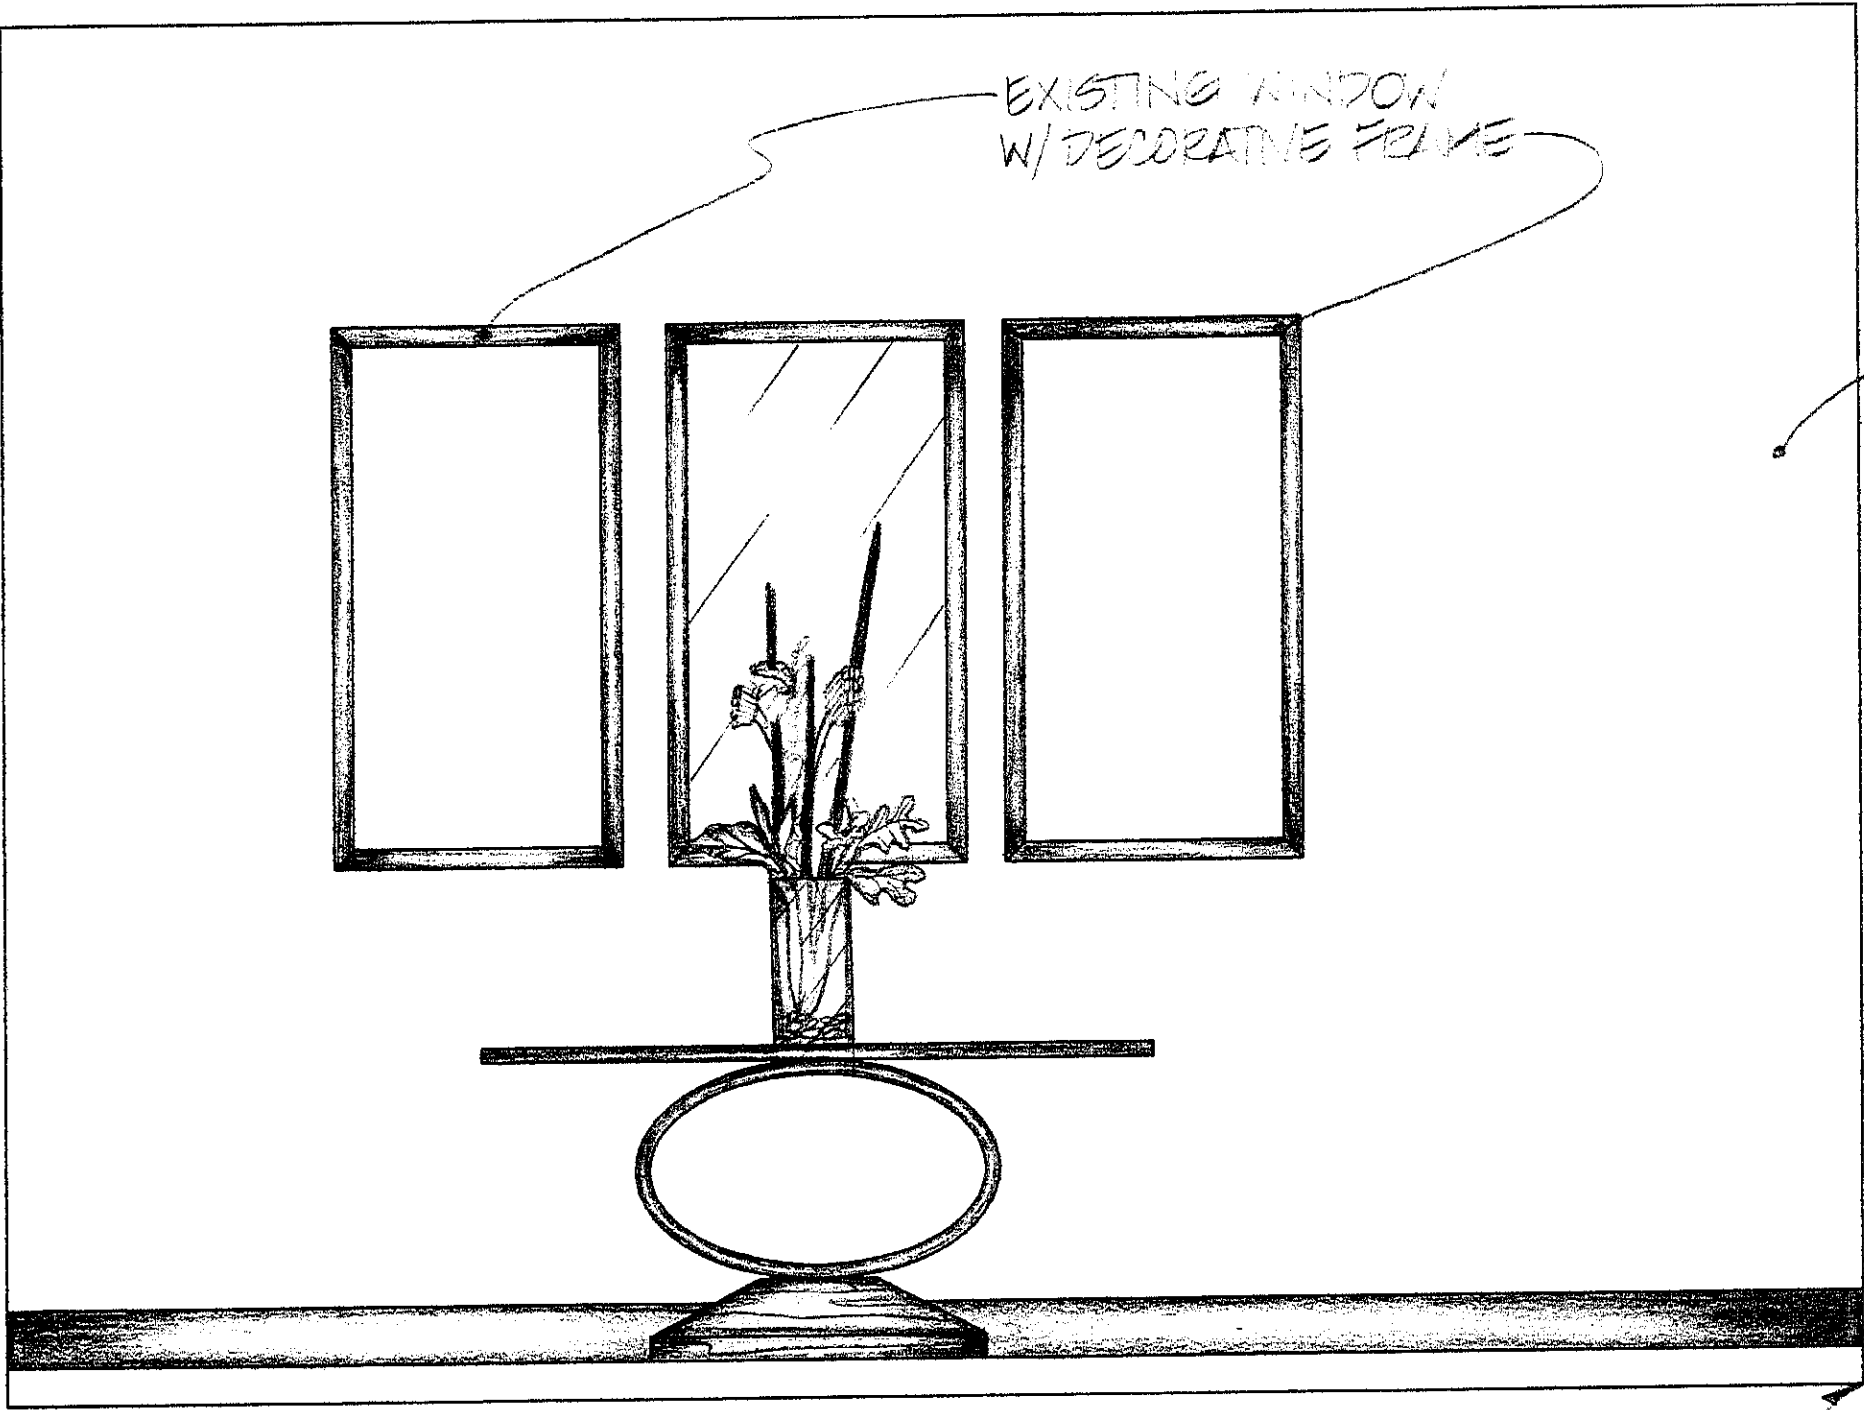

EXISTING WINDOW
W/ DECORATIVE FRAME

NEW F

 
EXIST FLOOR

ELEVATOR FOYER ELEVATION

SCALE: 1/8" = 1'-0"


INCREASE

PLATFORM



6th STREET

MOULDING
AROUND
WINDOW
TO BE
STAIN
GRADE

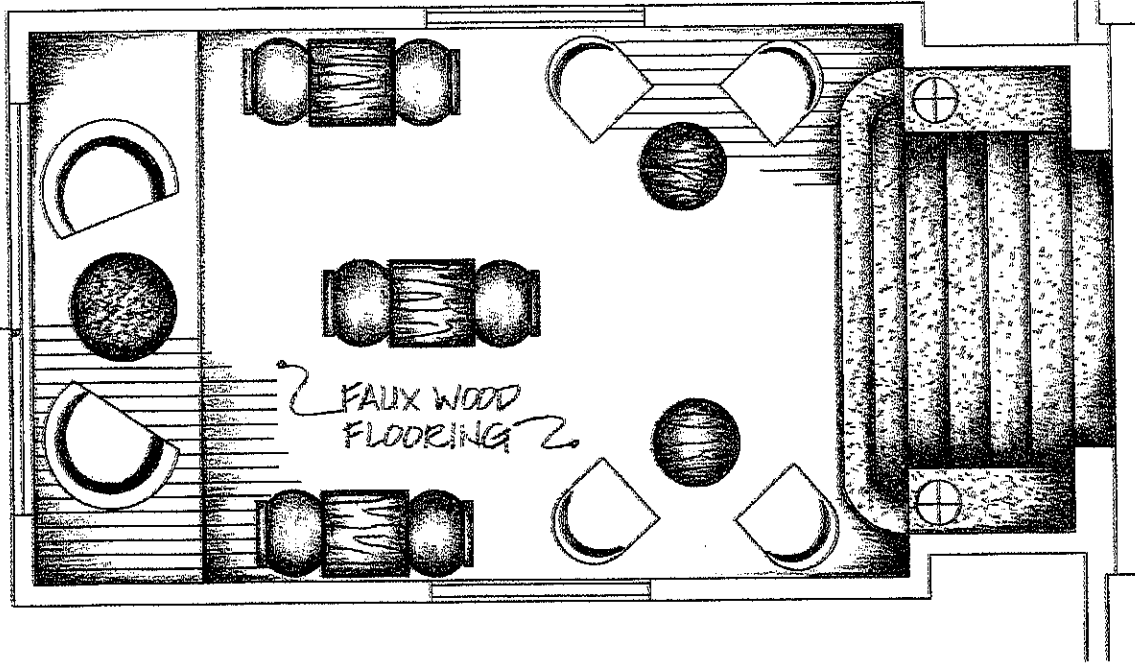


FAUX WOOD
FLOORING

10TH FLOOR LOWER LEVEL

SCALE: 1/4" = 1'-0"


10/5/10

NTS

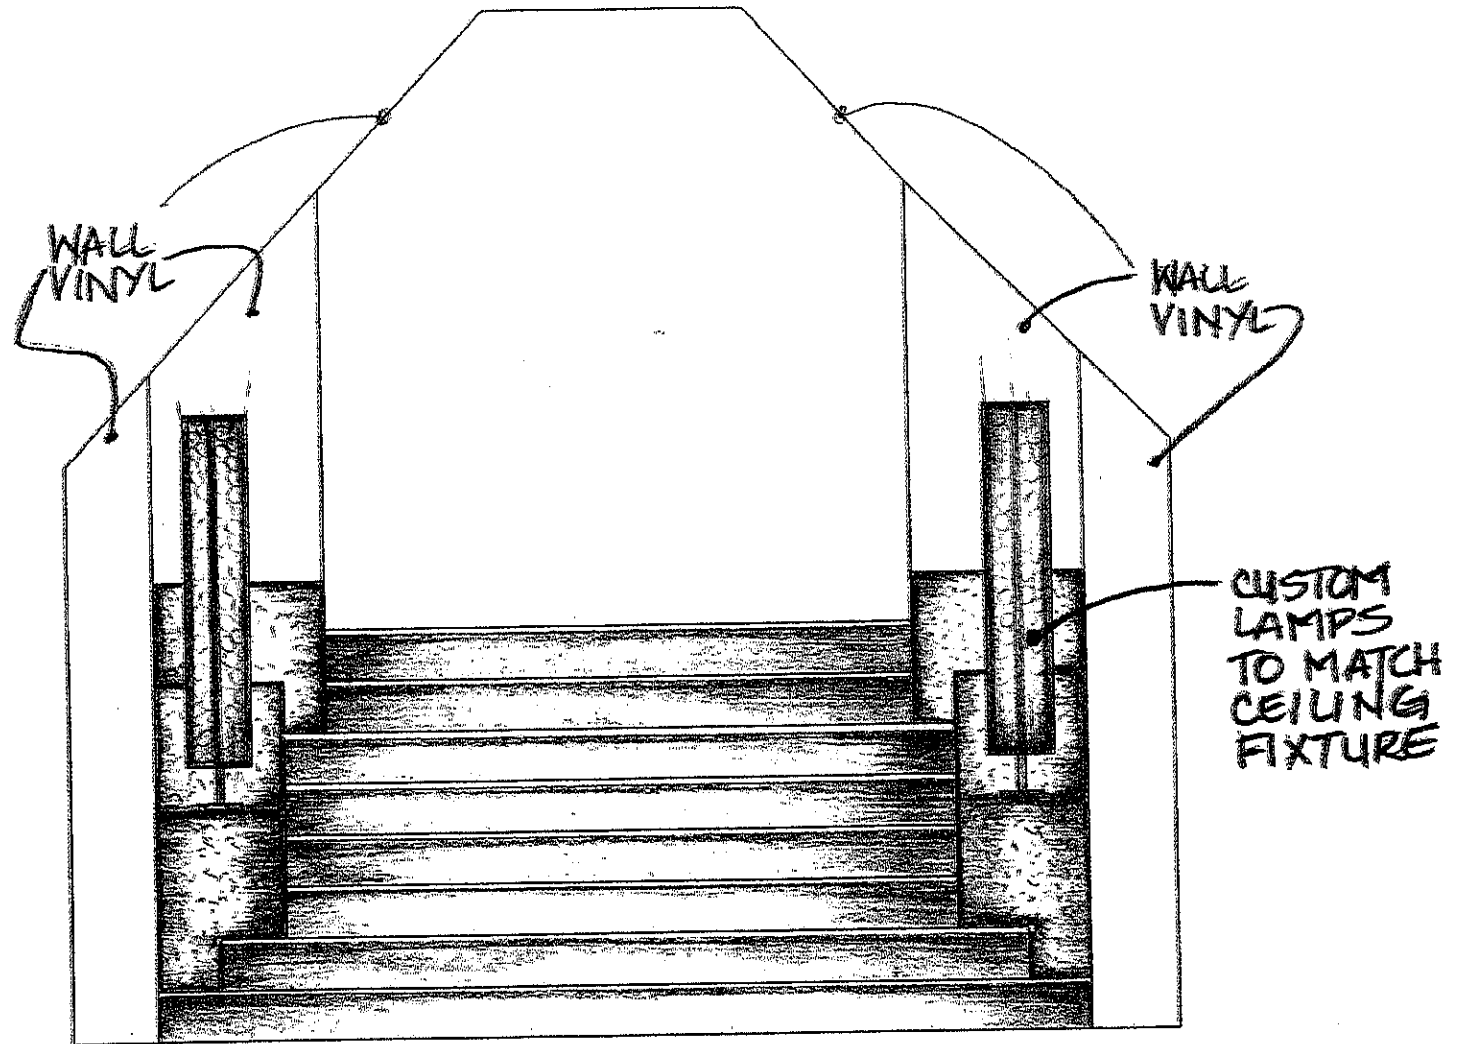

10TH FLOOR LOWER LEVEL
SCALE: 1/2" = 1'-0"

10/5/10
NTS

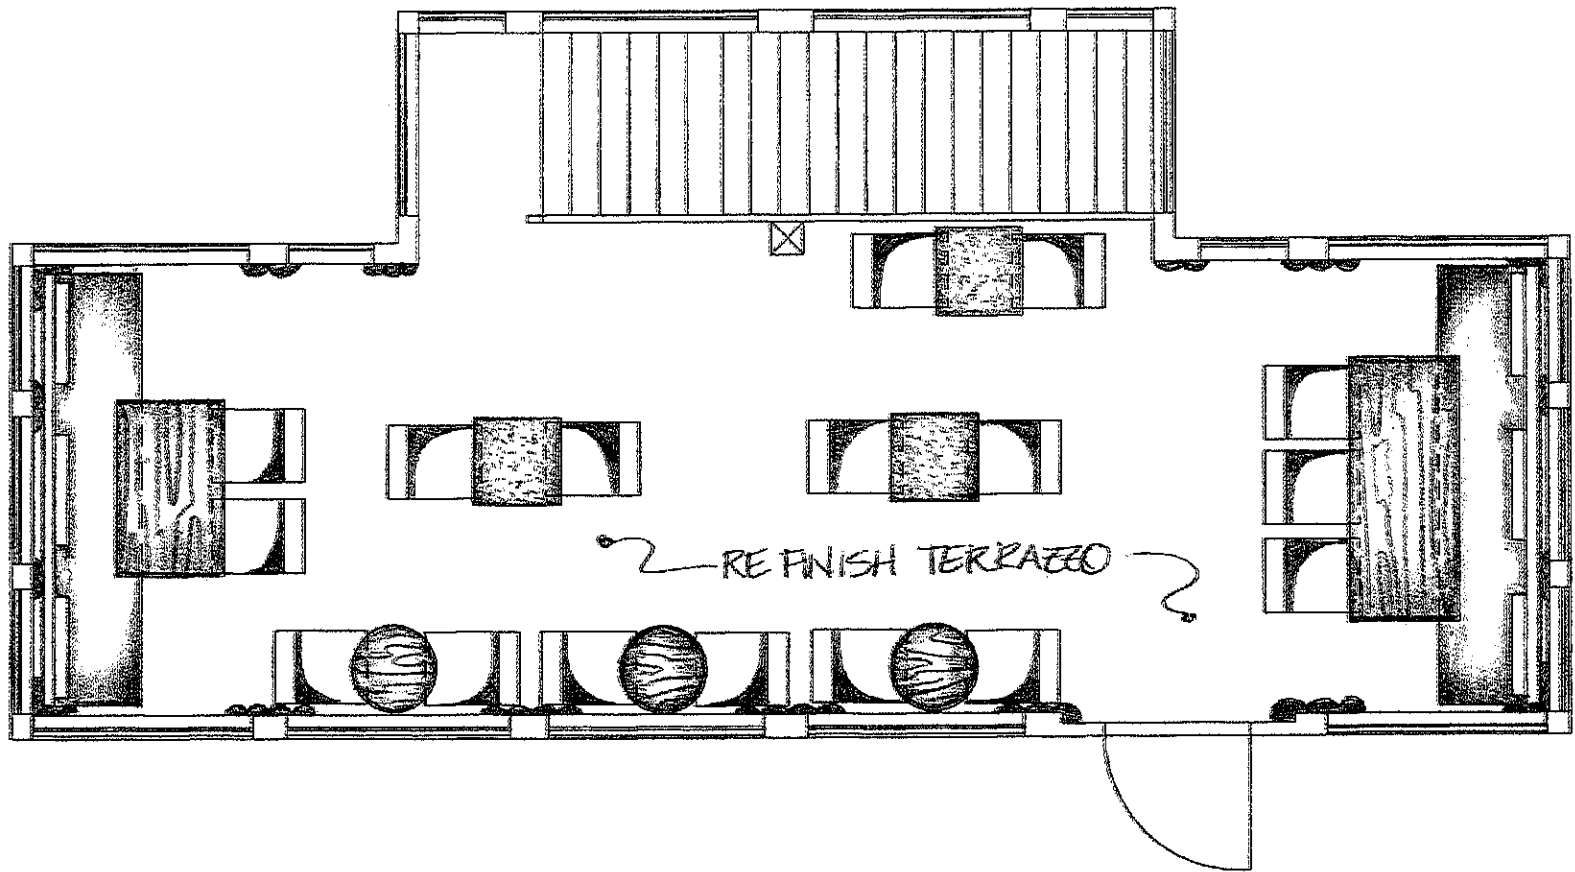


11TH FLOOR FURNITURE PLAN

SCALE: 1/4" = 1'-0"

10/5/10

NTS

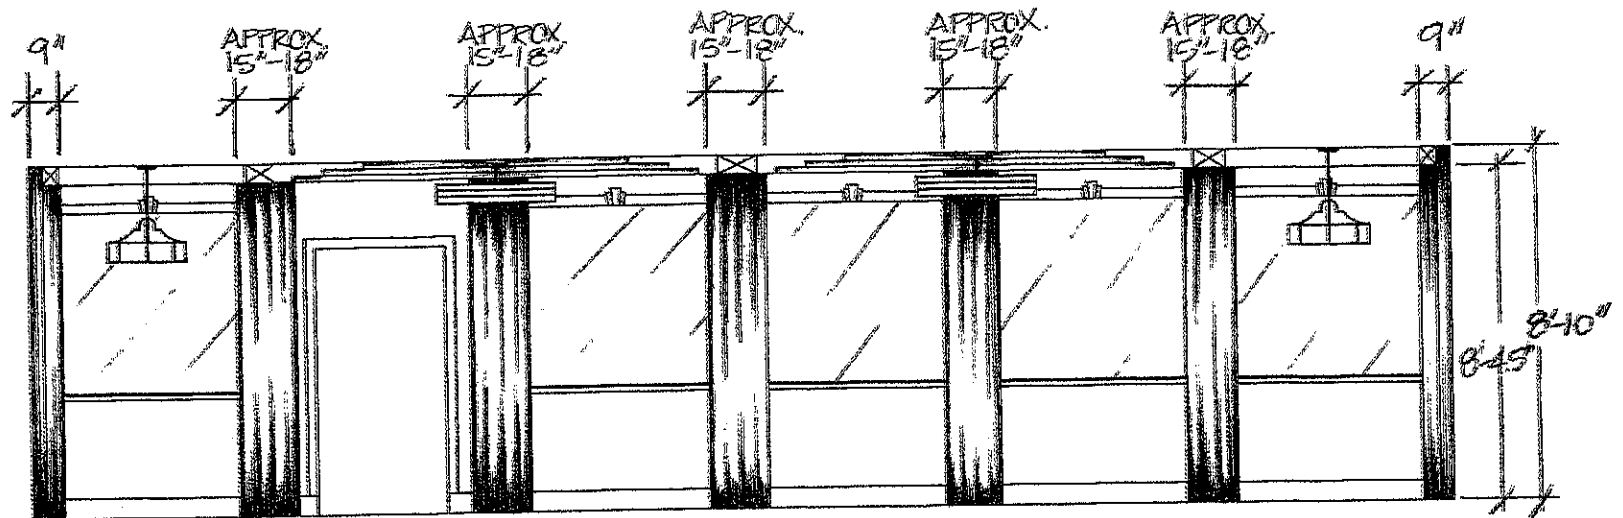


11TH FLOOR ELEVATION

SCALE: 1/4" = 1'-0"

10/5/10

NTS

* MUST FIELD MEASURE & VERIFY DIMENSIONS *

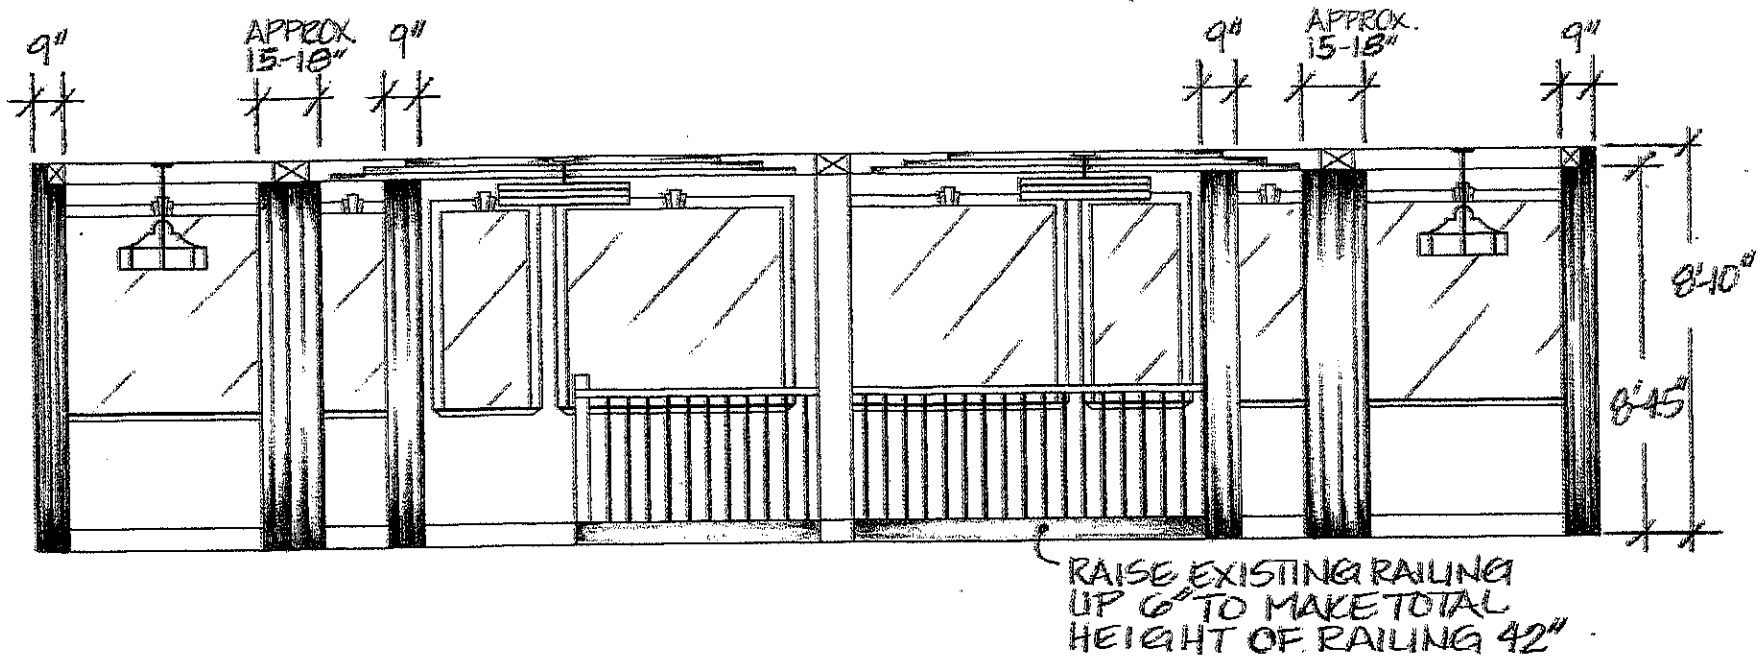


11TH FLOOR ELEVATION

SCALE: 1/4" = 1'-0"

10/5/10
NTS

* MUST FIELD MEASURE & VERIFY DIMENSIONS *

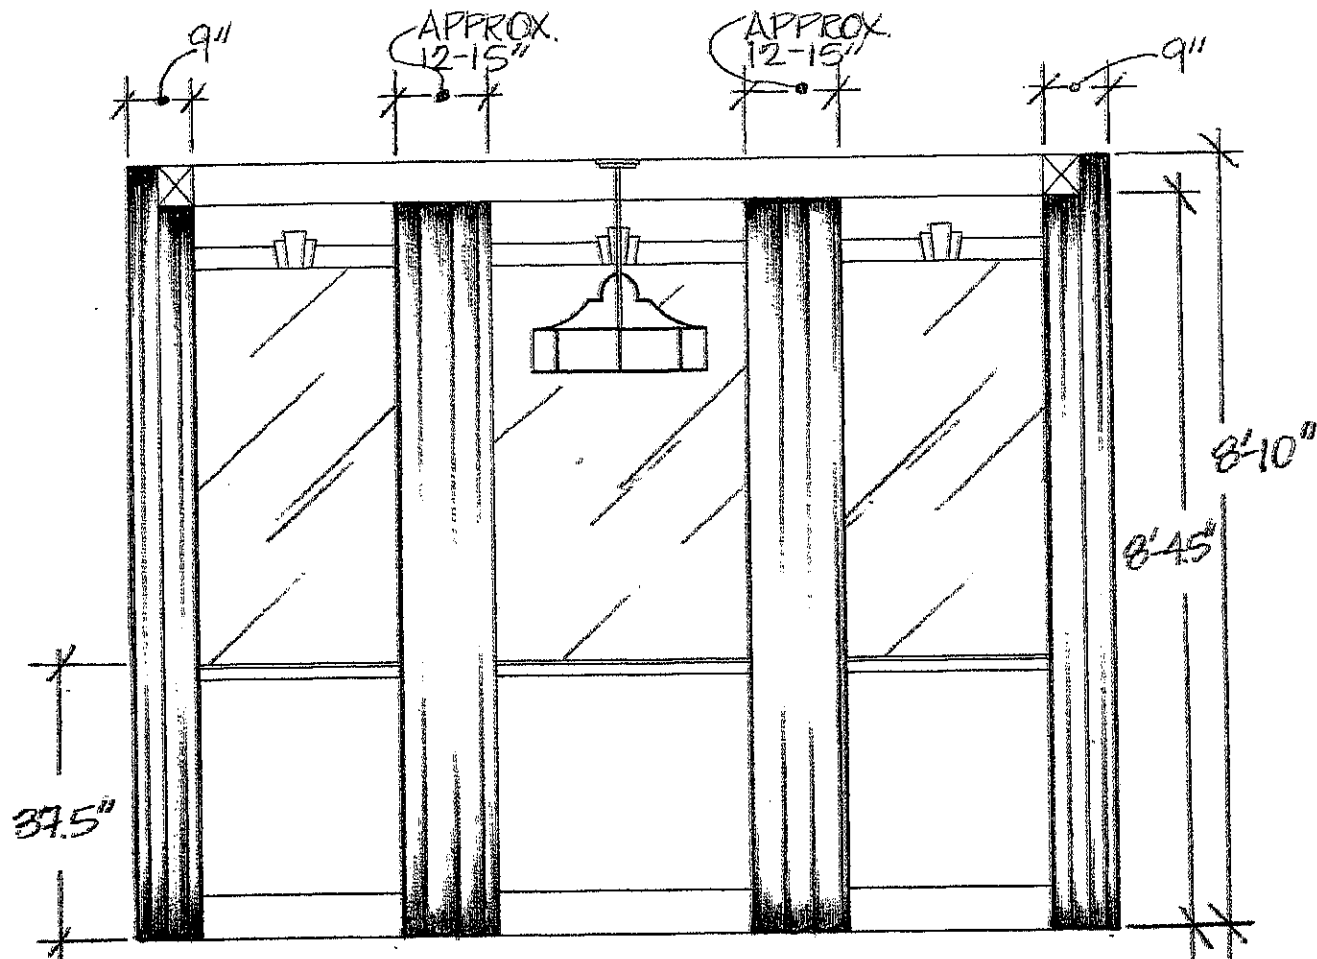


11TH FLOOR ELEVATION

10/5/10

SCALE: 1/2" = 1'0"


NTS

* MUST FIELD MEASURE & VERIFY DIMENSIONS *

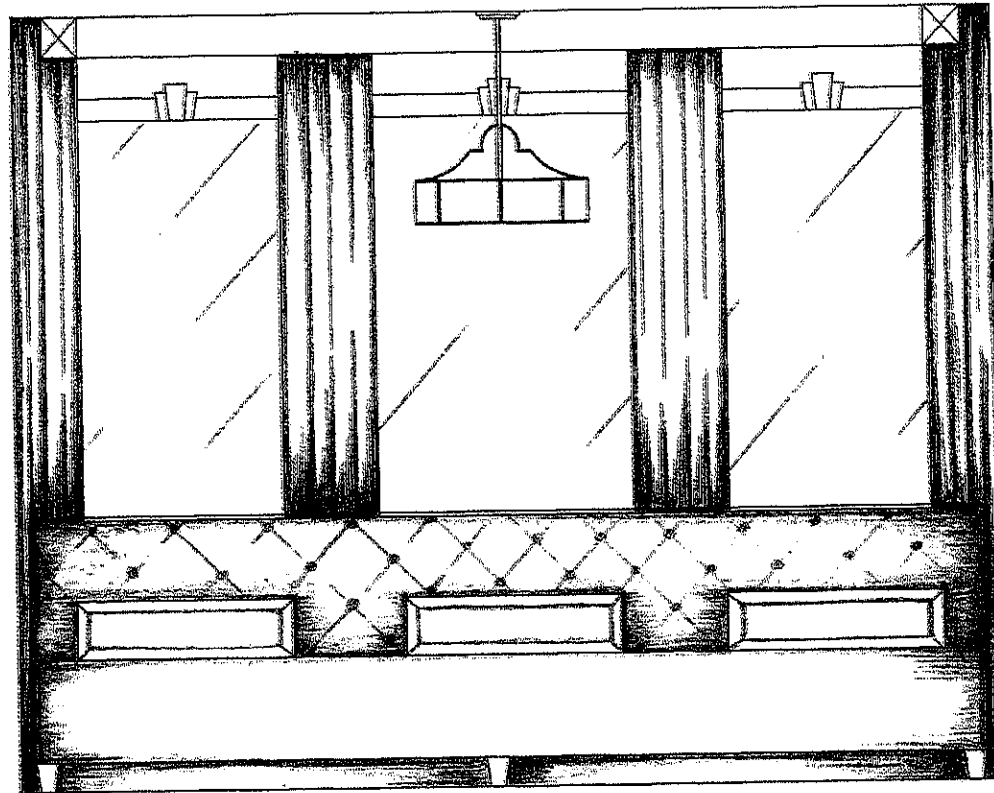

11TH FLOOR BANQUETTE CONCEPT
SCALE: $\frac{1}{2}$ " = 1'-0"

10/5/10
NTS

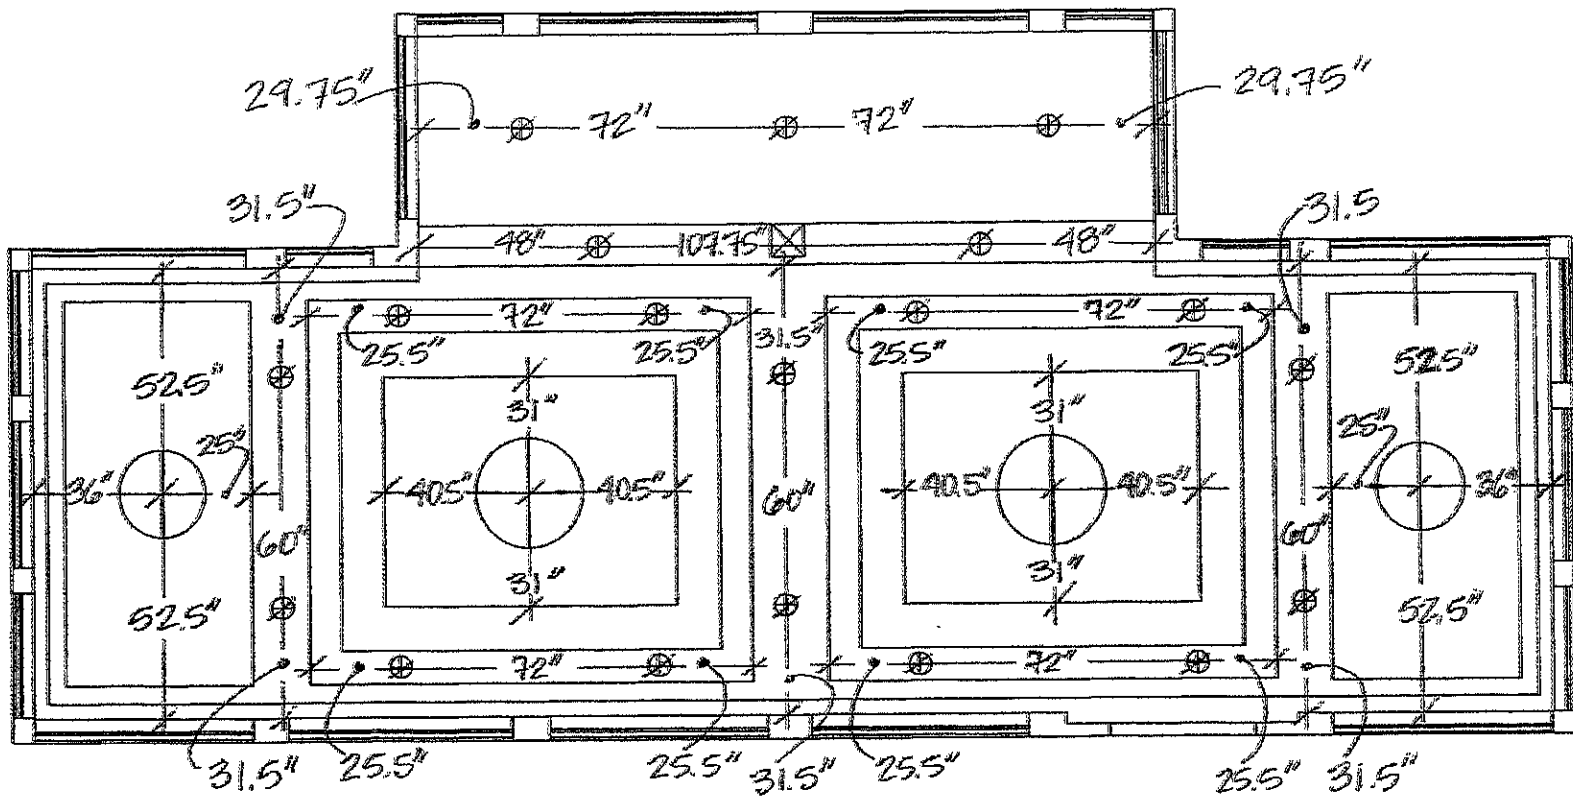


11TH FLOOR LIGHTING PLAN

SCALE: 1/4" = 1'-0"

10/5/10

NTS

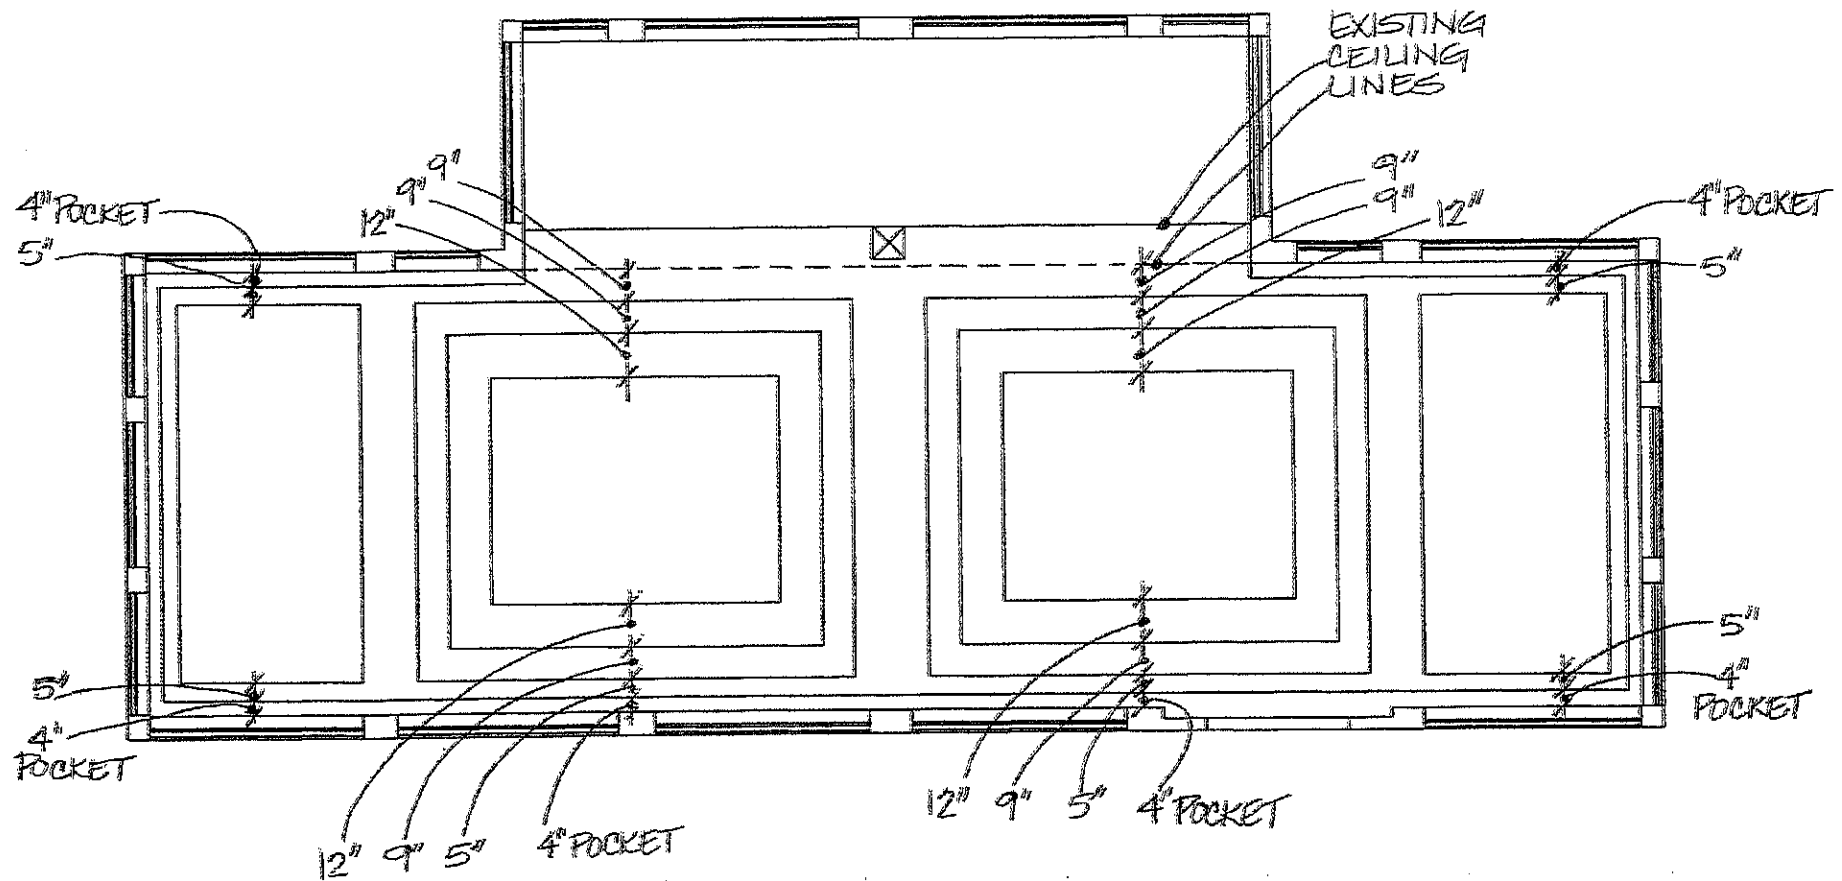


11TH FLOOR REFLECTED CEILING PLAN

SCALE: 1/4" = 1'-0"

* MUST FIELD MEASURE & VERIFY DIMENSIONS*

10/5/10
NTS

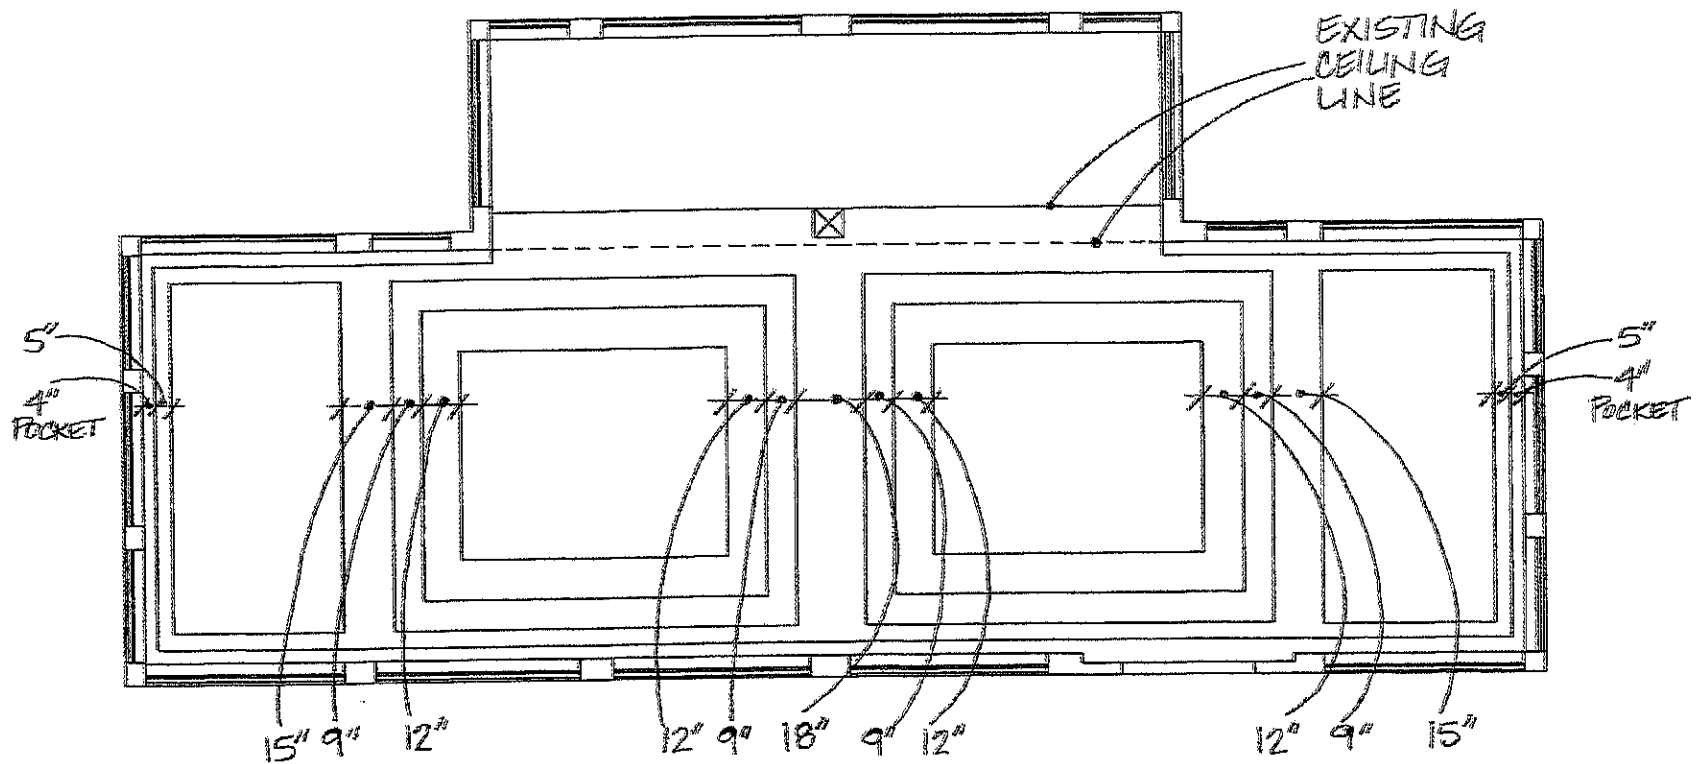

11TH FLOOR REFLECTED CEILING PLAN

SCALE: 1/4" = 1'-0"

* MUST FIELD MEASURE & VERIFY DIMENSIONS *

10/5/10
NTS

BENJAMIN MOORE
COLOR: 1B BLUE HAZE
#1667

BENJAMIN MOORE
COLOR: 1B BLUE STREAM
#1668

BENJAMIN MOORE
COLOR: 1B SARATOGA SPRINGS
#1669

5.5" SHEET ROCK
CEILING

33" PAINTED
BANDS

1/2" METAL STRIPS

BENJAMIN MOORE
COLOR: 2B LABRADOR BLUE
#1670

BENJAMIN MOORE
COLOR: 2B WEST COAST #1671

BENJAMIN MOORE
COLOR: 3B ALFRESCO #1672

BENJAMIN MOORE
COLOR: 3B VERMONT SLATE #1673

10TH & 11TH FLOOR STAIRWELL ELEV.

SCALE: 1/4" = 1'-0"

* MUST FIELD MEASURE & VERIFY DIMENSIONS *

10/5/10
NTS