


02SR019

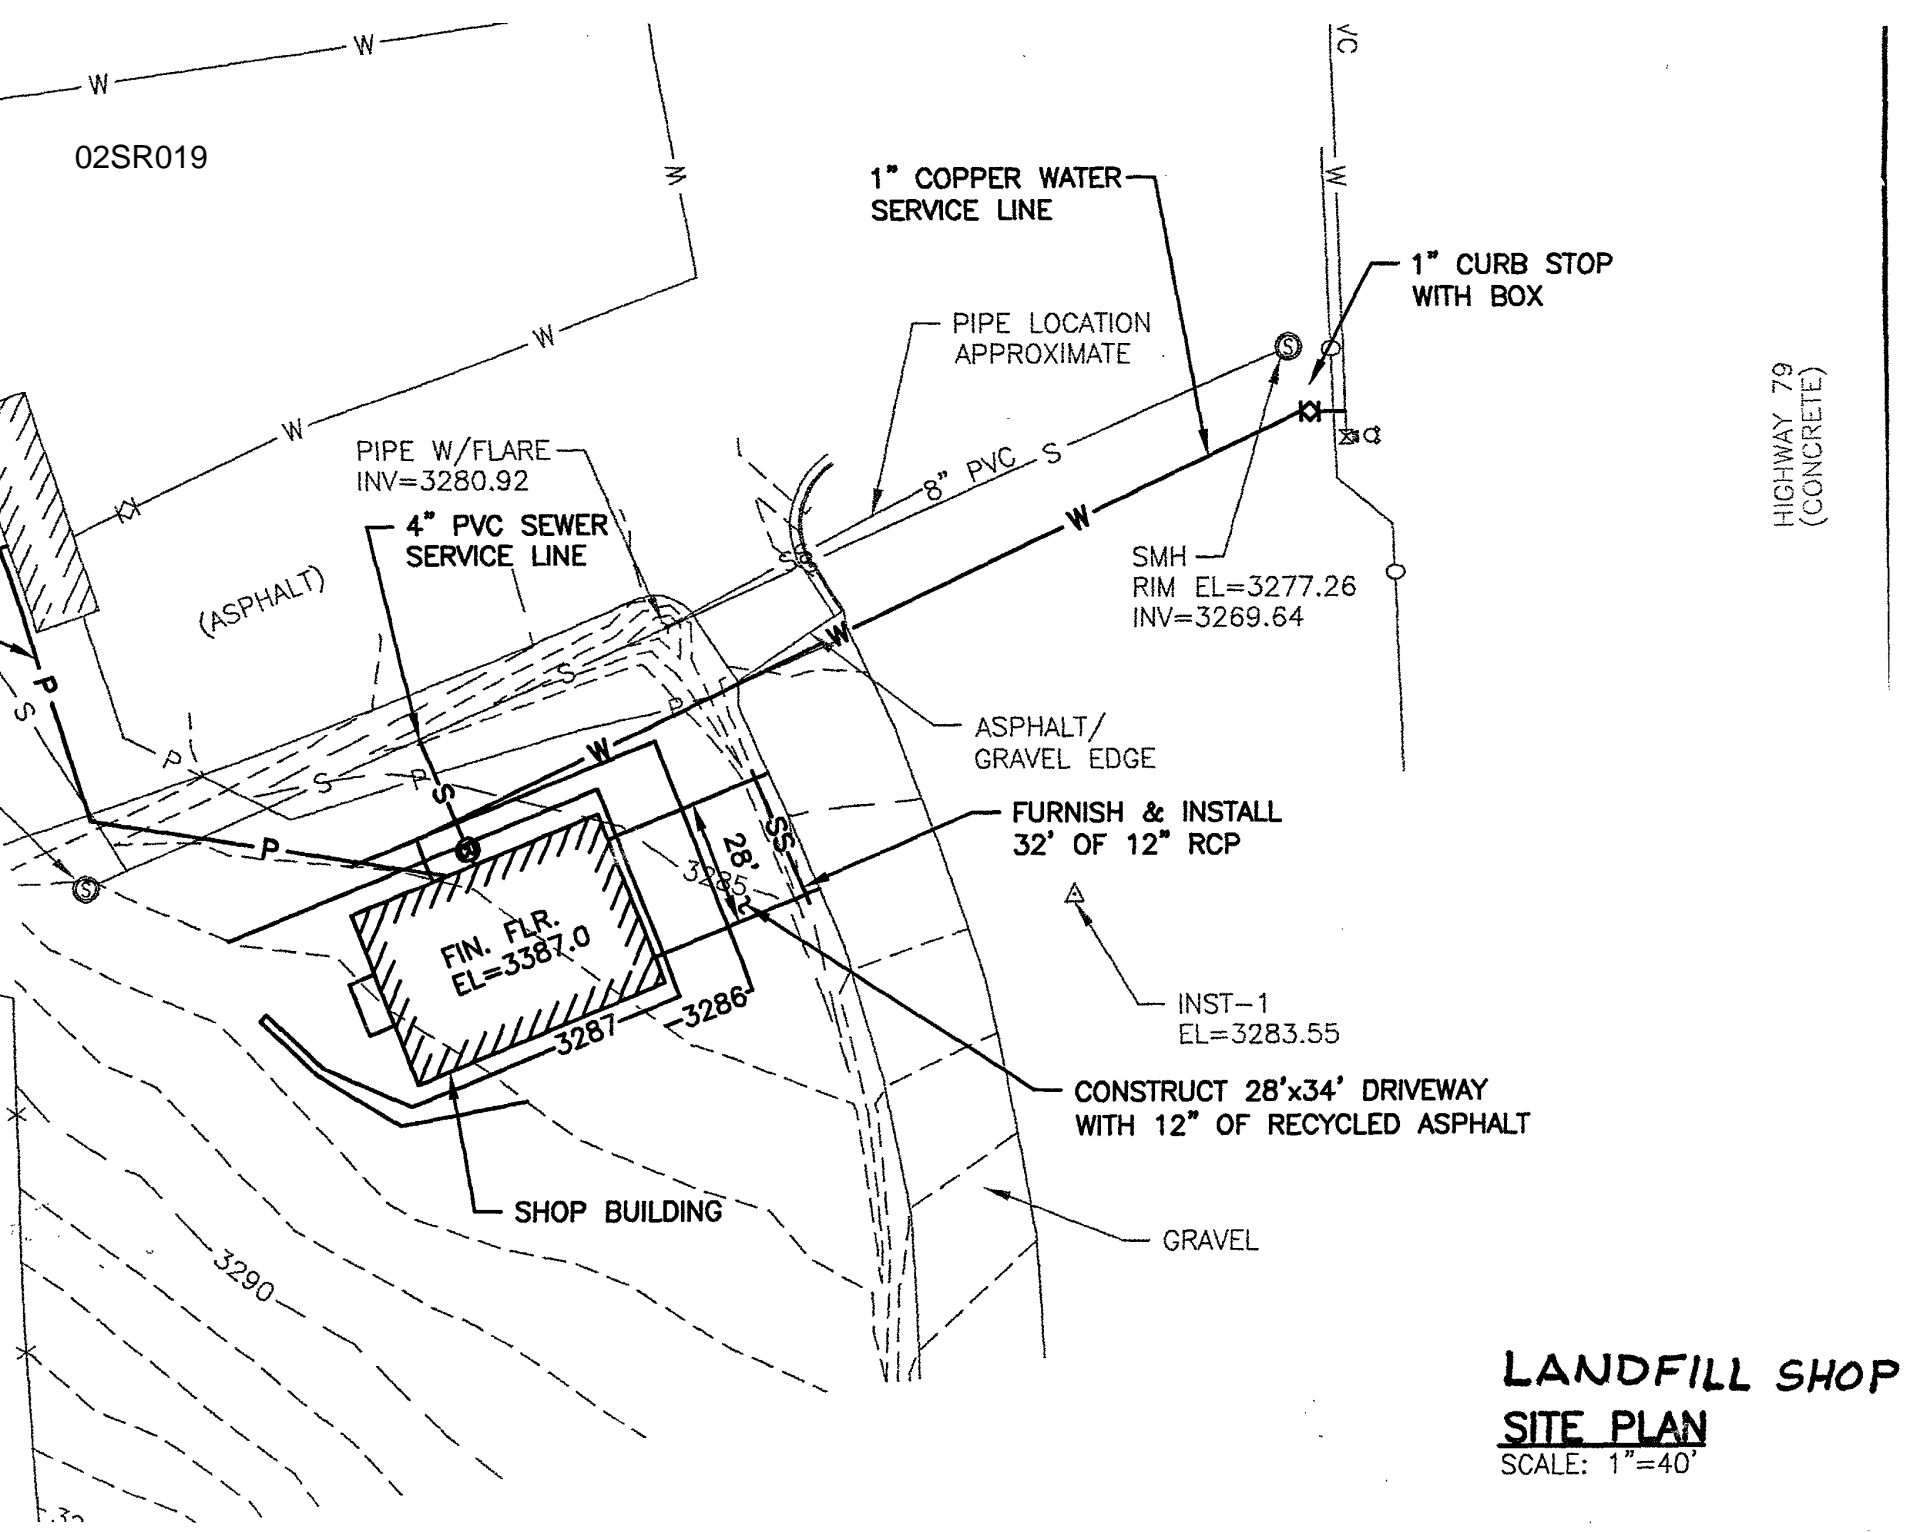

1" COPPER WATER SERVICE LINE

1" CURB STOP WITH BOX

PIPE LOCATION APPROXIMATE

8" PVC S

PIPE W/FLARE
INV=3280.92

4" PVC SEWER SERVICE LINE

SMH
RIM EL=3277.26
INV=3269.64

HIGHWAY 79
(CONCRETE)

ASPHALT/
GRAVEL EDGE

FURNISH & INSTALL
32' OF 12" RCP

INST-1
EL=3283.55

CONSTRUCT 28'x34' DRIVEWAY
WITH 12" OF RECYCLED ASPHALT

SHOP BUILDING

GRAVEL

LANDFILL SHOP

SITE PLAN

SCALE: 1"=40'