

NEW 2-ANTENNA  
ARRAY SET BACK  
6 FEET FROM ROOF EDGE  
(TYPICAL OF 3)


NEW POWER & TELEPHONE  
SERVICE CONDUITS THRU  
STAIRWELL TO BASEMENT

ANTENNA FRAME  
NON-PENET. TYPE


NEW COBLES ON  
NON-PENETRATING  
SUPPORT BLOCKS

NEW EQUIPT.  
CABTS. FOR  
VERIZON  
WIRELESS ON  
NON-PENET.  
PLATFORM

RCY DTRAPIDCITY  
19 FEB 03 DMW DESIGN 1

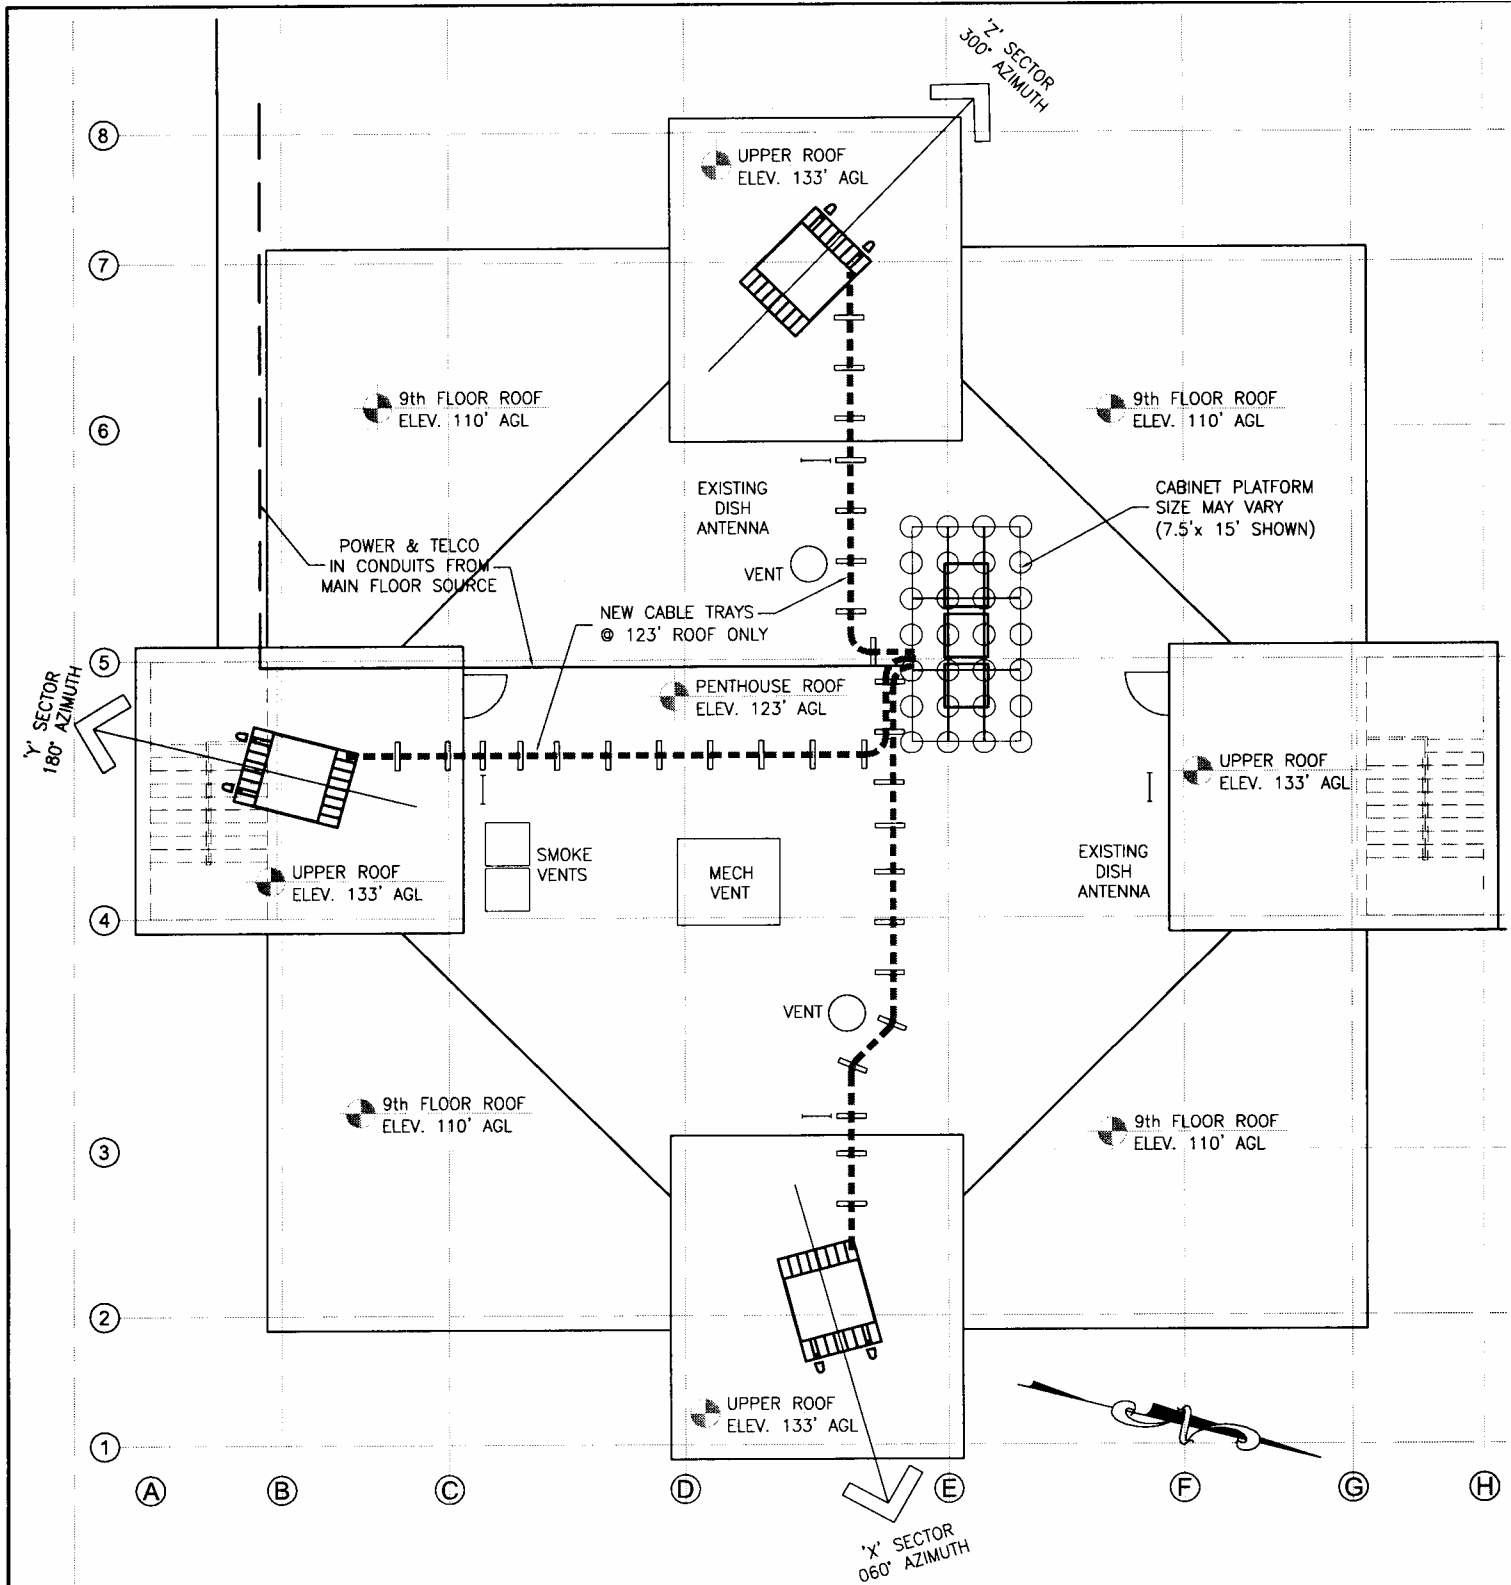

# ROOF PLAN

 


**DESIGN** **1**  
OF EDINA, LTD.  
 9573 VALLEY VIEW ROAD  
 EDEN PRAIRIE, MN 55344  
 (952) 903-0290 FAX 903-0292  
 ROBERT J. DAVIS, AIA  
 ARCHITECT

**VERIZON WIRELESS**  
 9955 59th Avenue North  
 Suite # 120  
 Plymouth, MN 55442  
 (763) 585-5102


PROJECT: 01066303584  
**RCY DT RAPID CITY  
 US BANK BUILDING**  
 909 ST JOSEPH STREET  
 RAPID CITY, SD 57701

DRAWN BY: DMW  
 DATE: 26 FEB 03  
**1 OF 3**

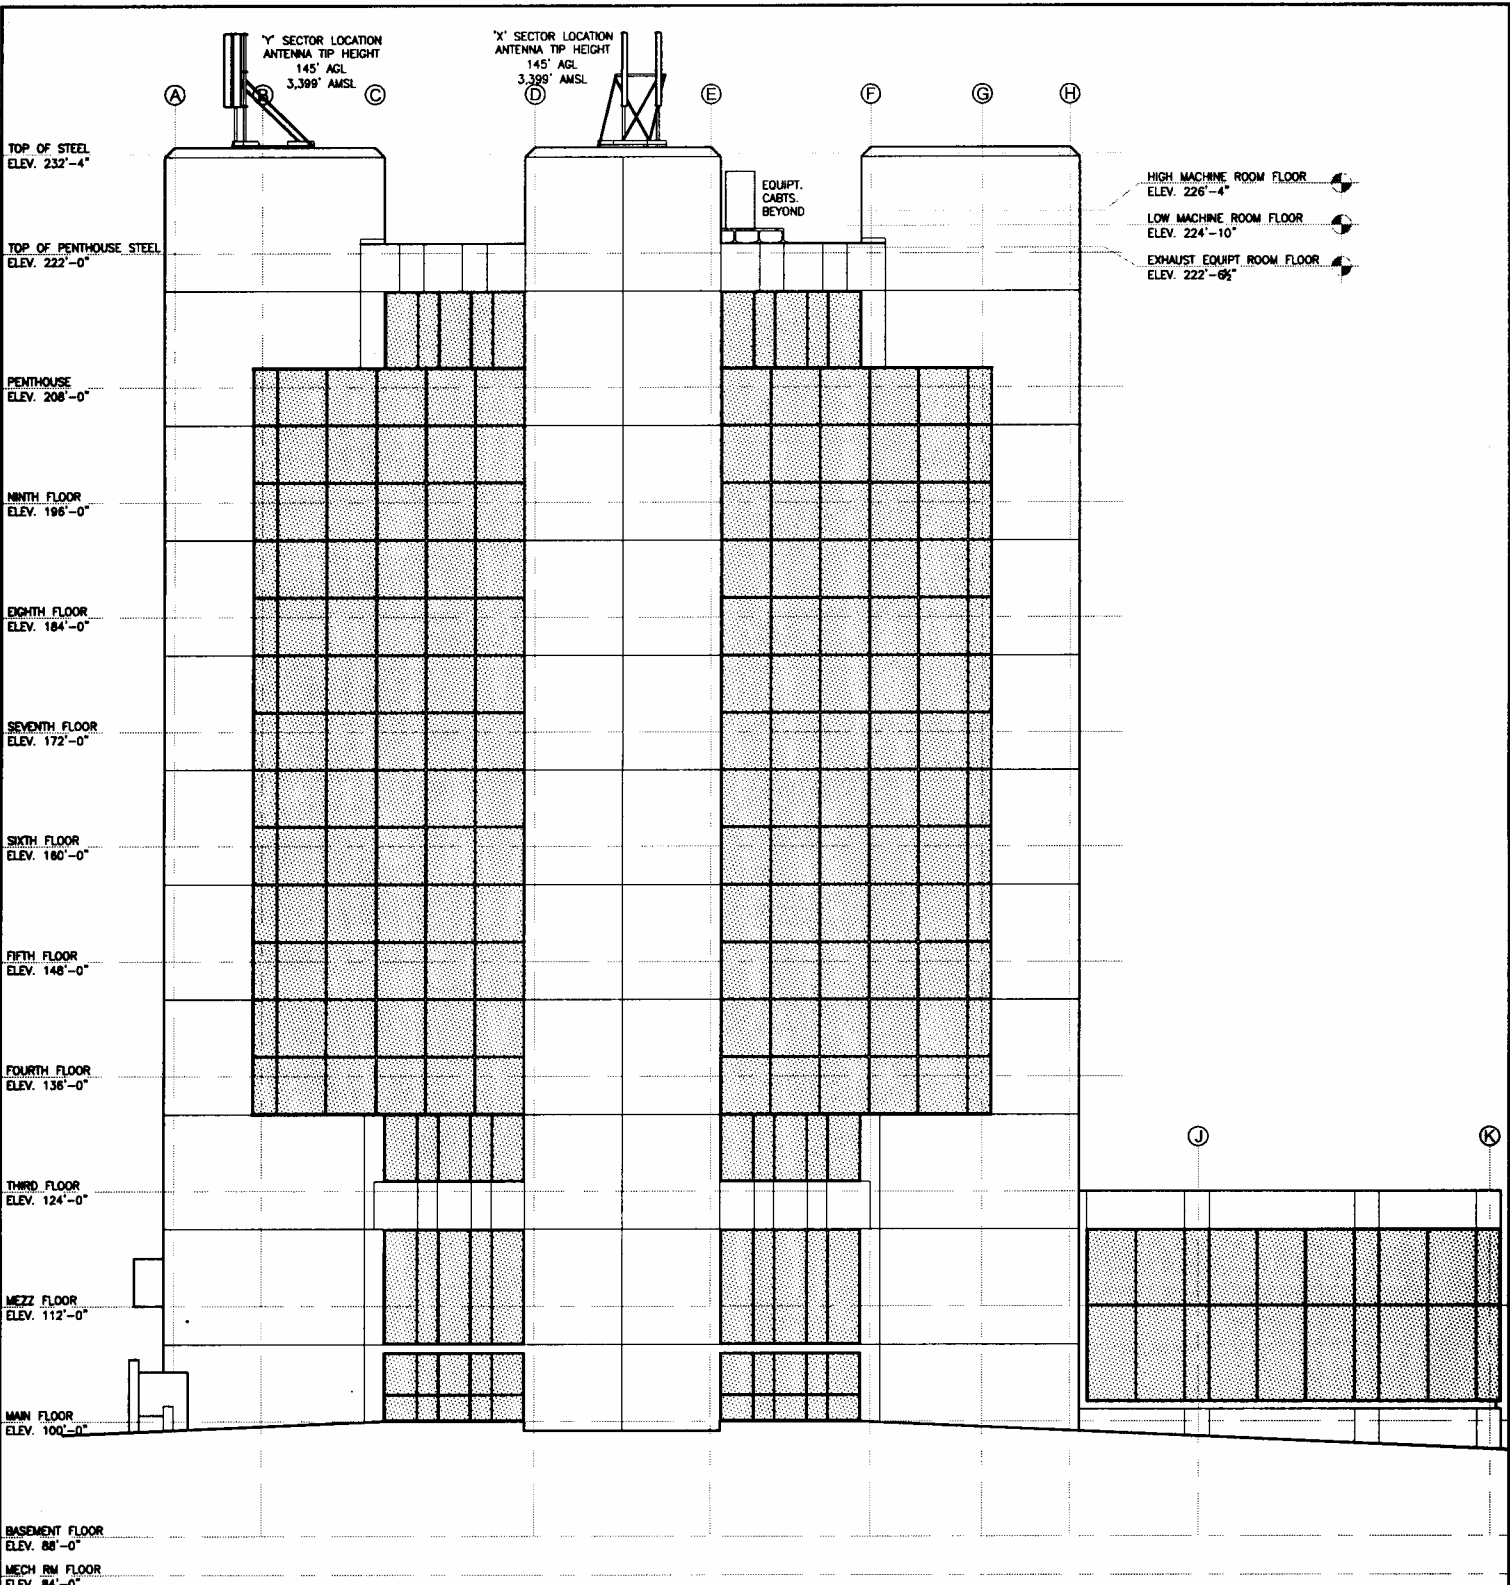

# EAST SIDE

 GRAPHIC SCALE







**DESIGN**  
OF EDINA, LTD.  
8873 VALLEY VIEW ROAD  
EDEN PRAIRIE, MN 55344  
(888) 803-8298 FAX 953-9292  
ROBERT J. DAVIS, AIA  
ARCHITECT

**VERIZON WIRELESS**  
9955 59th Avenue North  
Suite # 120  
Plymouth, MN 55442  
(763) 595-5102

PROJECT: 01066303584  
**RCY DT RAPID CITY  
US BANK BUILDING**  
909 ST JOSEPH STREET  
RAPID CITY, SD 57701

 DRAWN BY: DMW  
DATE: 26 FEB 03  
2 OF 3

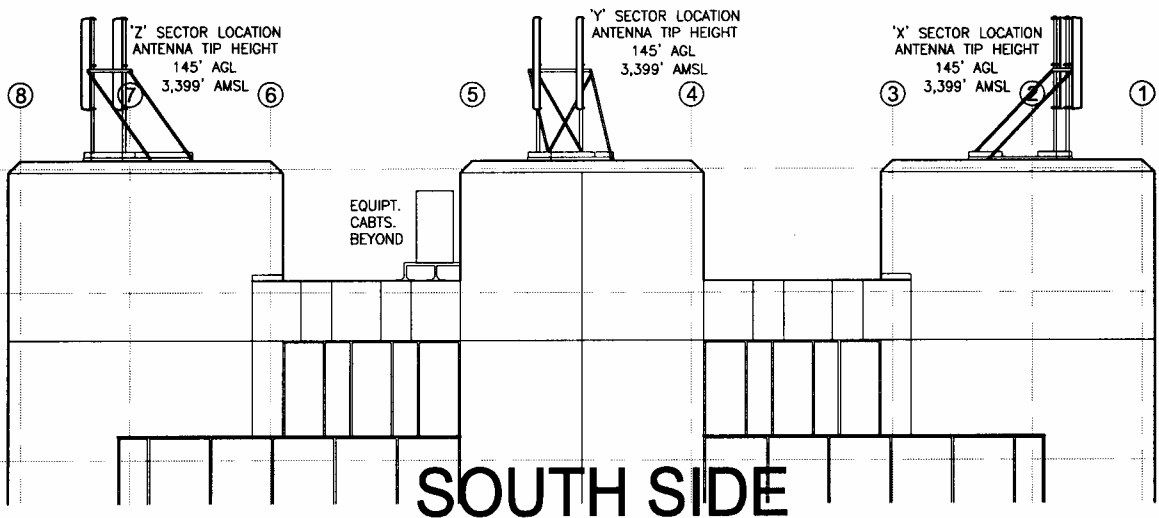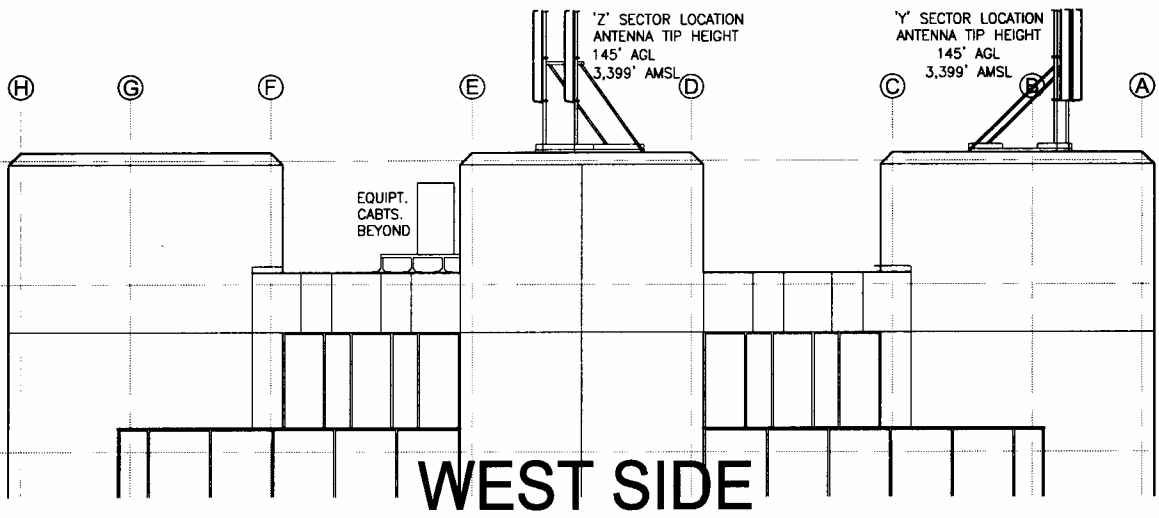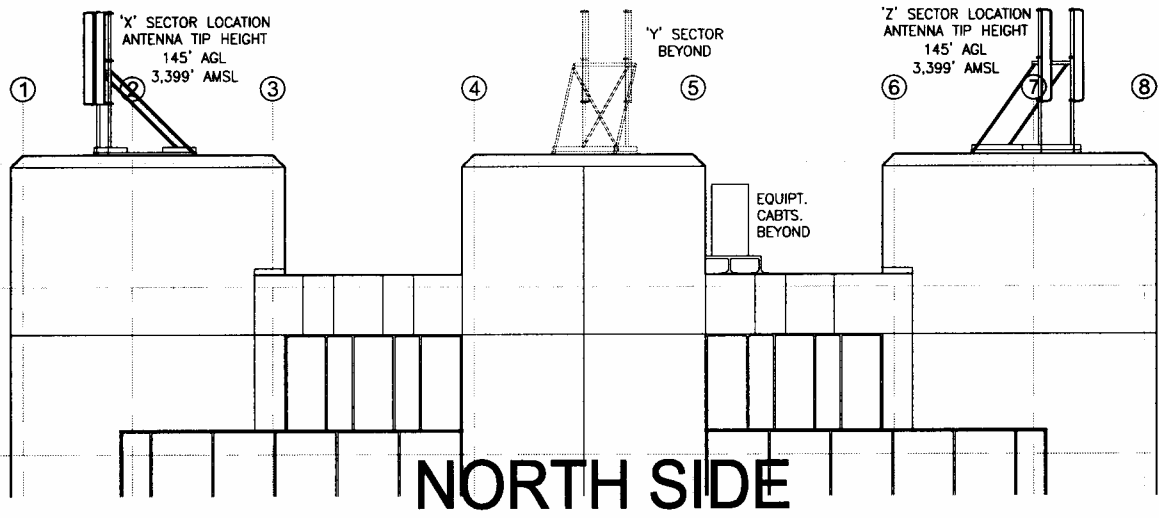

**DESIGN** 

OF EDINA, LTD.  
9873 VALLEY VIEW ROAD  
EDINA PRairie, MN 55344  
(952) 803-8280 FAX 952-8282


ROBERT J. DAVIS, AIA  
ARCHITECT

**VERIZON WIRELESS**

9955 59th Avenue North  
Suite # 120  
Plymouth, MN 55442  
(763) 585-5102

PROJECT: 01066303584  
**RCY DT RAPID CITY  
US BANK BUILDING**  
909 ST JOSEPH STREET  
RAPID CITY, SD 57701

DRAWN BY: DMW  
DATE: 26 FEB 03  
**3 OF 3**

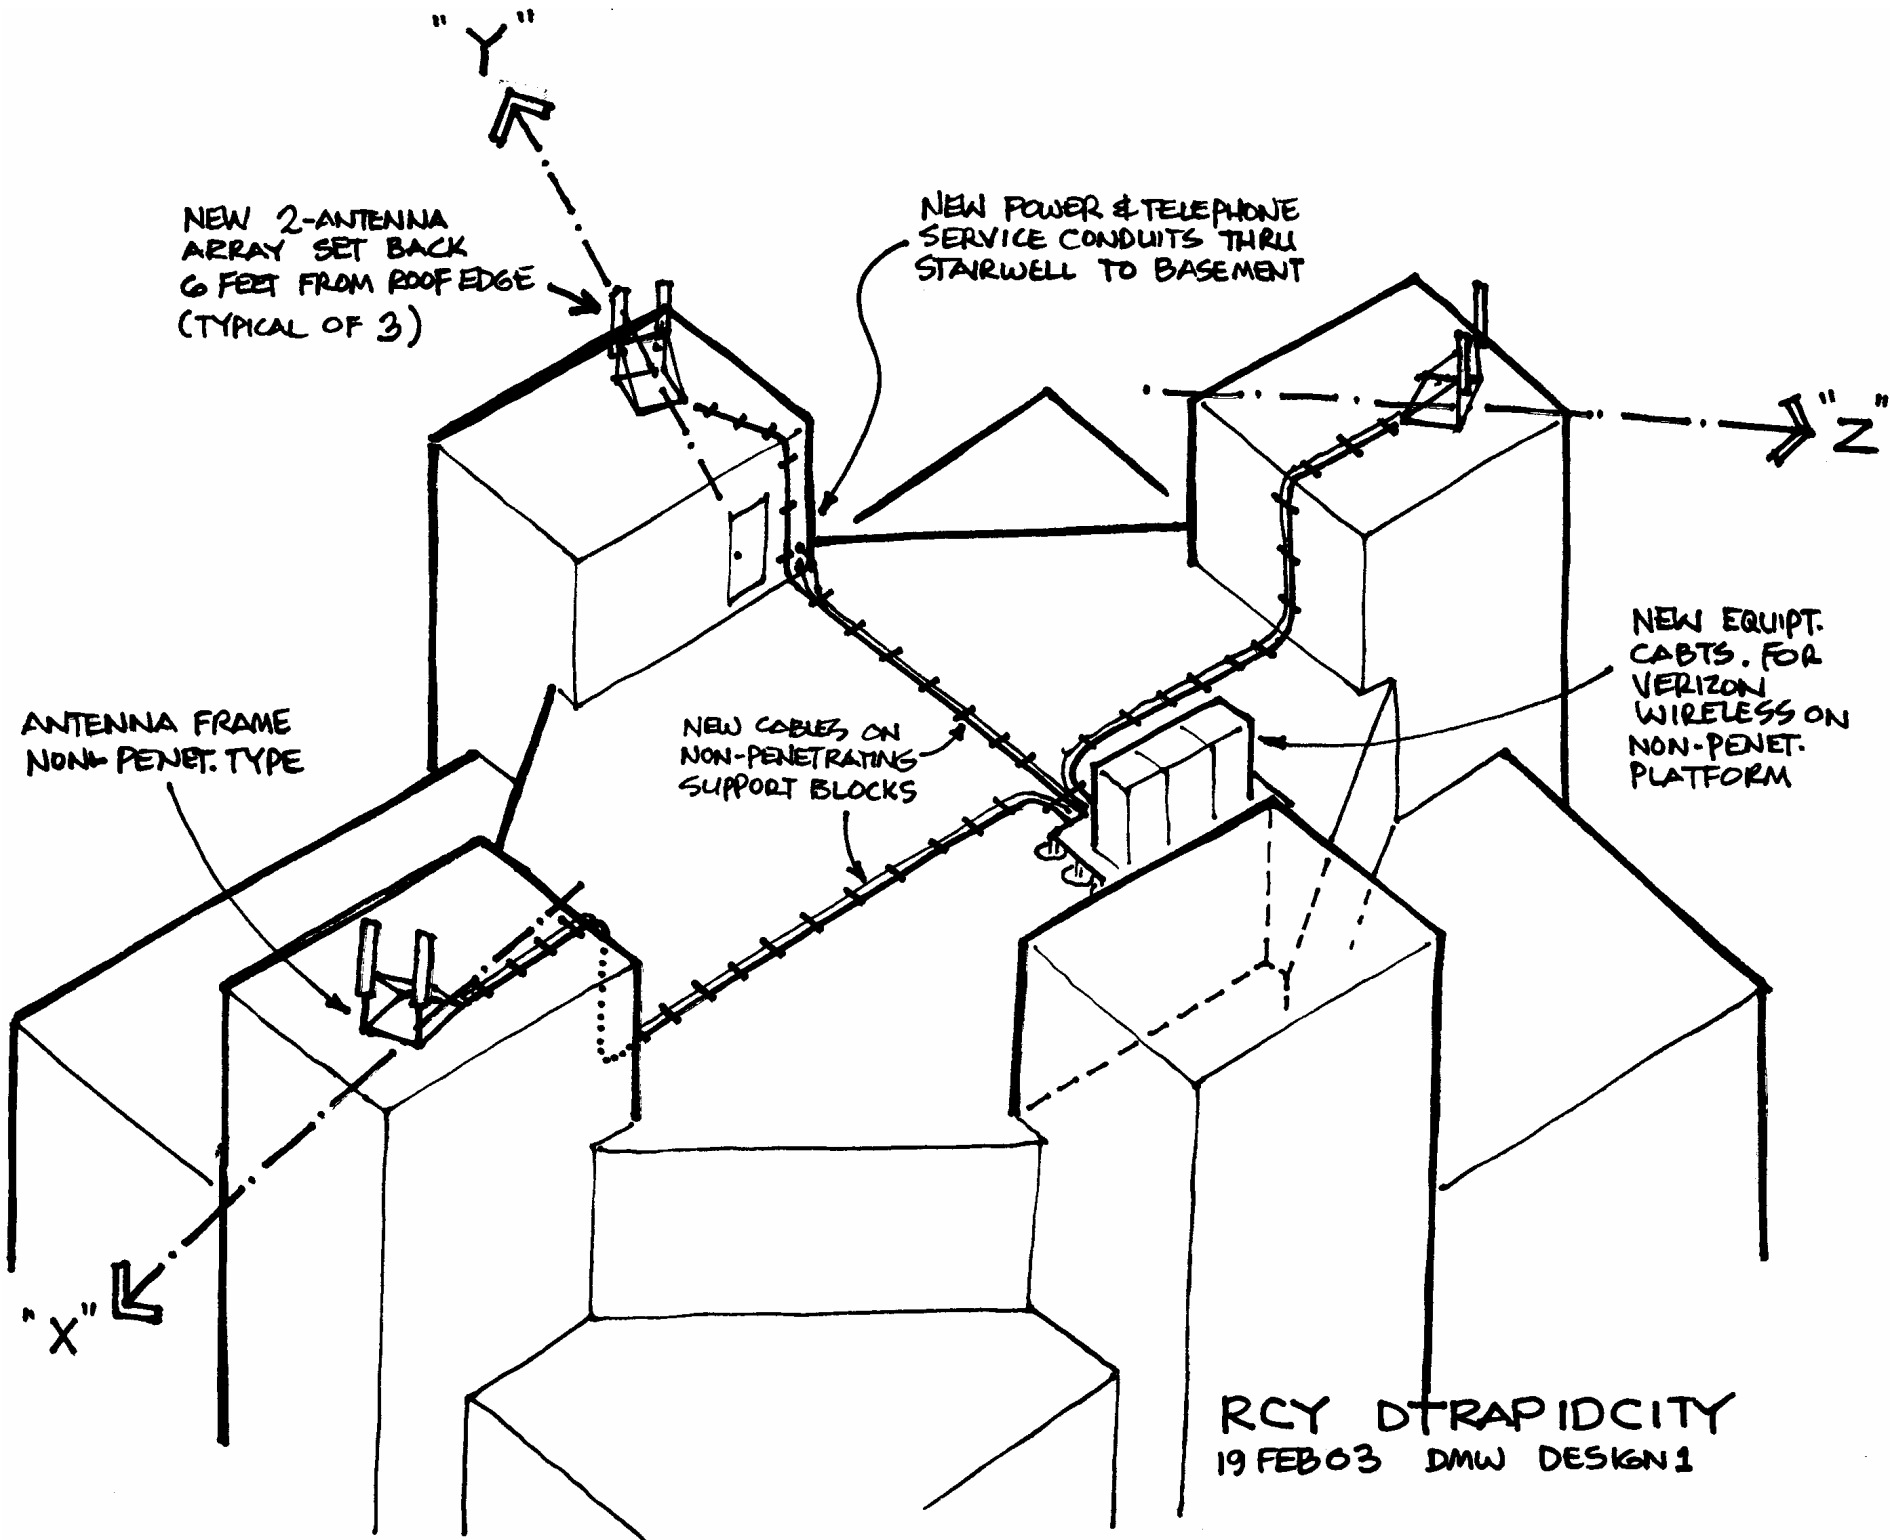

NEW 2-ANTENNA  
ARRAY SET BACK  
6 FEET FROM ROOF EDGE  
(TYPICAL OF 3)

NEW POWER & TELEPHONE  
SERVICE CONDUITS THRU  
STAIRWELL TO BASEMENT

ANTENNA FRAME  
NON-PENET. TYPE

NEW CABLES ON  
NON-PENETRATING  
SUPPORT BLOCKS

NEW EQUIPT.  
CABTS. FOR  
VERIZON  
WIRELESS ON  
NON-PENET.  
PLATFORM

RCY DTRAPIDCITY  
19 FEB 03 DMW DESIGN 1