


REDUCE DNL OF HVAC EQUIPMENT TO 65 DNL AT PROPERTY LINE
PRIVACY/SOUND FENCE

112'-6"

REDUCE DNL OF HVAC EQUIPMENT TO 65 DNL AT PROPERTY LINE
PRIVACY/SOUND FENCE

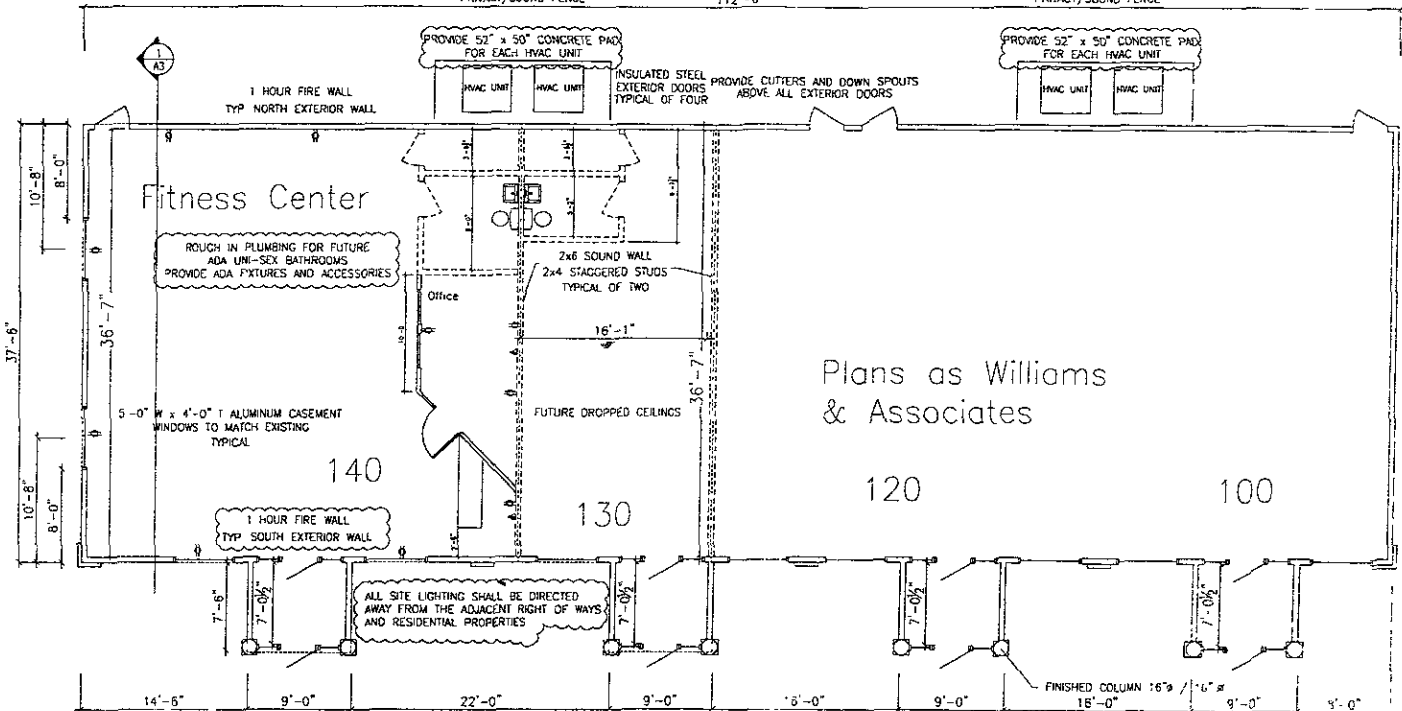

Plans as Williams & Associates

140

130

120

100

ALL SITE LIGHTING SHALL BE DIRECTED AWAY FROM THE ADJACENT RIGHT OF WAYS AND RESIDENTIAL PROPERTIES

FINISHED COLUMN : 6" / 16" or 18" - 0"



FLOOR PLAN


Scale: 3/32" = 1'-0"

EXISTING BUILDINGS CAN BE SEEN AT 740 SHEROAN LANE, RICHMOND

REDUCE DNL OF HVAC EQUIPMENT TO 65 DNL AT PROPERTY LINE
 PRIVACY/SOUND FENCE

112'-6"

REDUCE DNL OF HVAC EQUIPMENT TO 65 DNL AT PROPERTY LINE
 PRIVACY/SOUND FENCE

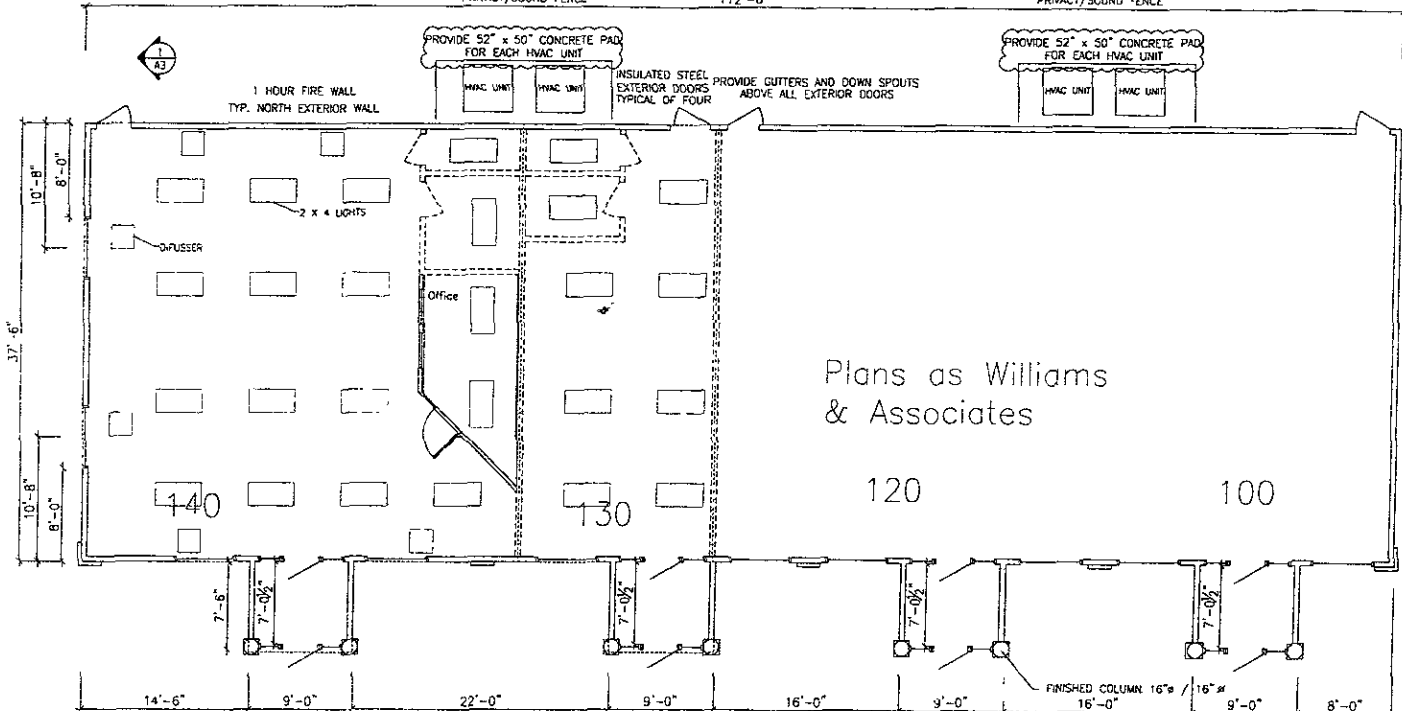

Plans as Williams
 & Associates

LIGHTING PLAN

Scale 3/32" = 1'-0"

EXISTING BUILDINGS CAN BE SEEN AT 740 SHERIDAN LAKE ROAD

REDUCE DNL OF HVAC EQUIPMENT TO 65 DNL AT PROPERTY LINE
 PRIVACY/SOUND FENCE

112'-6"

REDUCE DNL OF HVAC EQUIPMENT TO 65 DNL AT PROPERTY LINE
 PRIVACY/SOUND FENCE

