
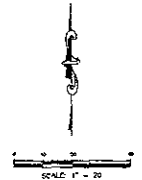


Fee Number: 8811  
 Location: CITY/STATE A  
 Title: PLS. 8/11/06  
 Surveyed By: T.W. JONES  
 Date: 8/11/06  
 Designed By: C.O.F.  
 Drawn By: C.O.F.  
 Checked By: C.O.F.

**FJORDS ICE CREAM & COFFEE SHOP**  
 CIVIL ENGINEERING SITE PLANS  
 RAPID CITY, SD

Revision / Date  
 Sheet Name:  
**TOPOGRAPHIC MAP**  
 Sheet Number:  
**C2**

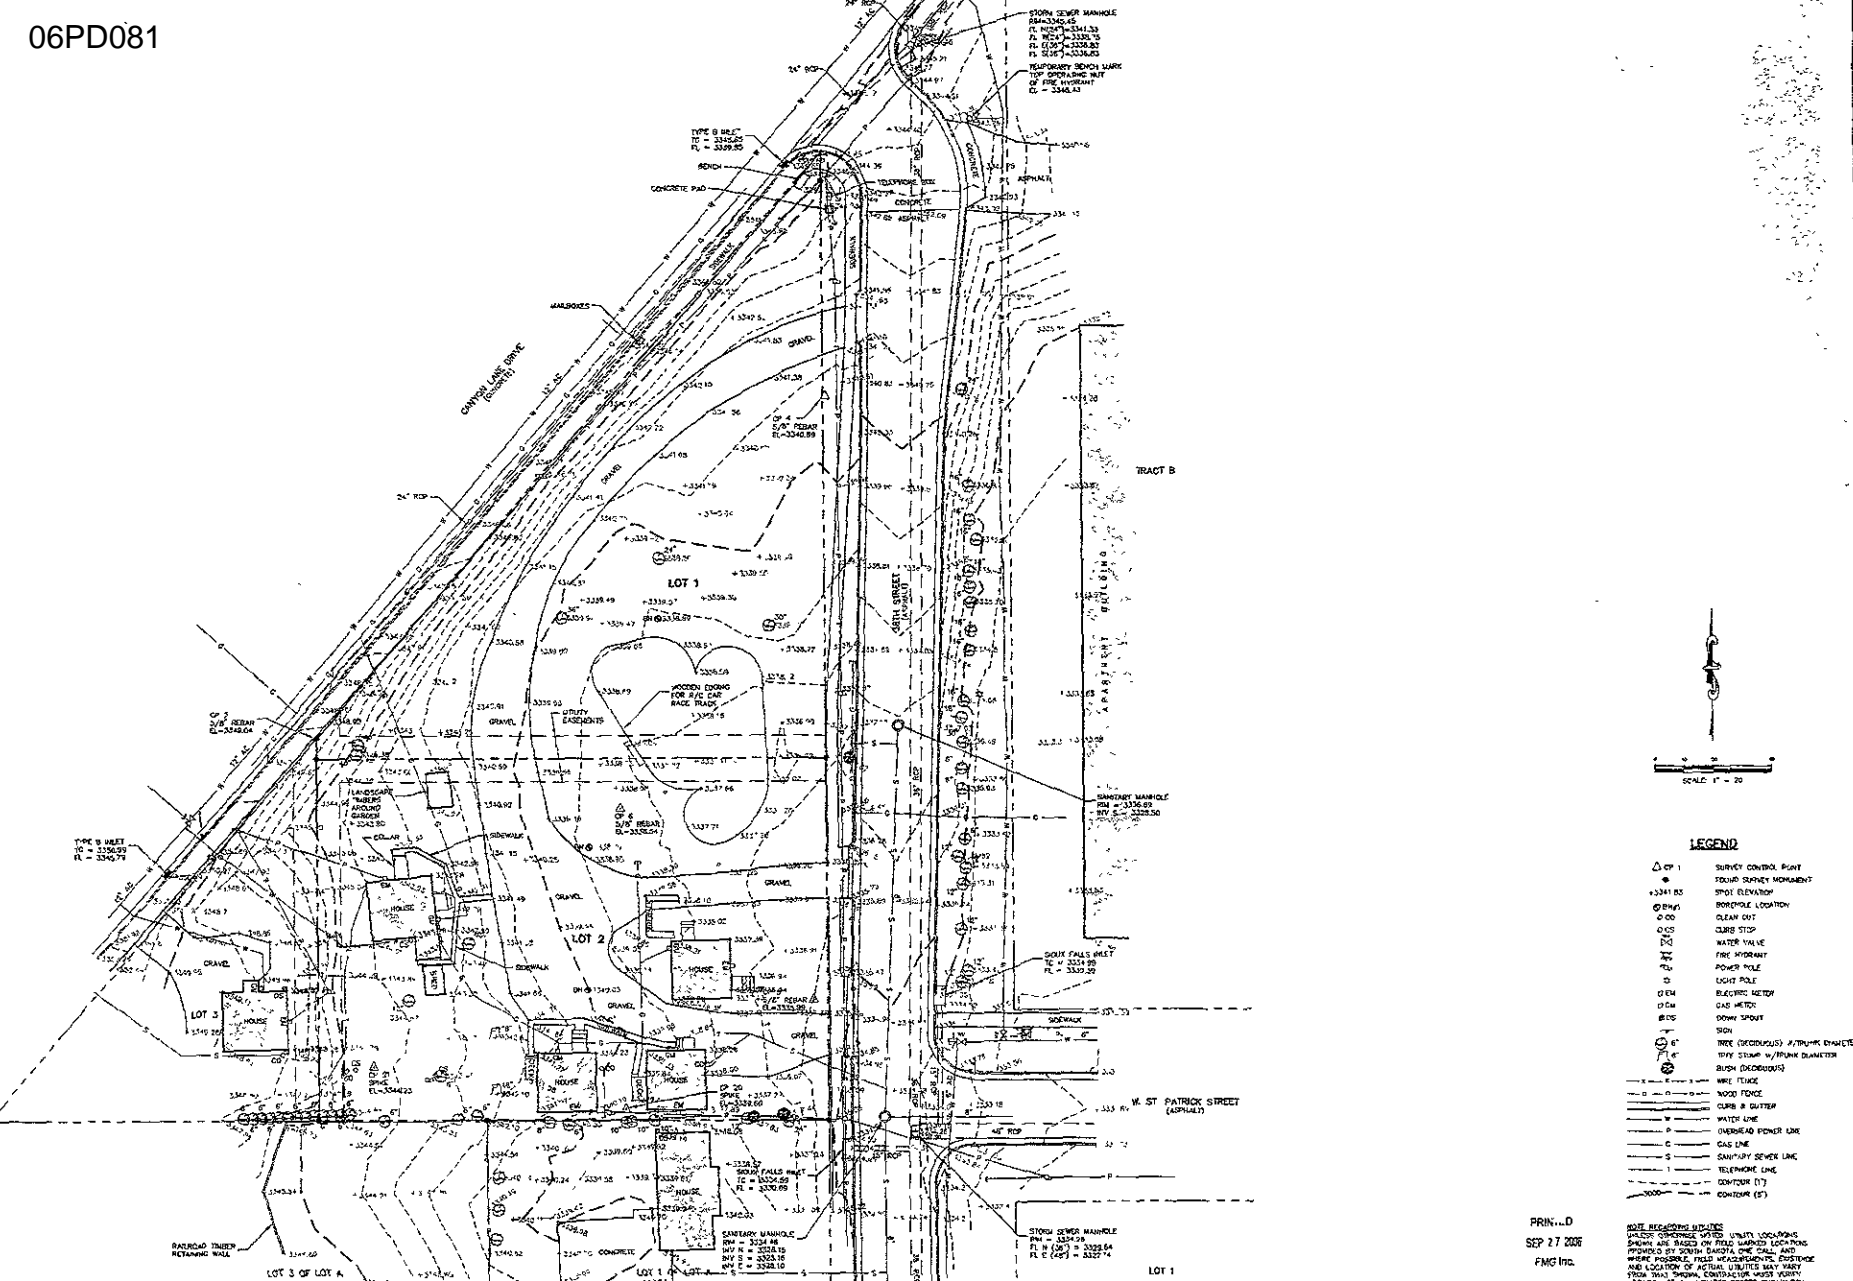

**LEGEND**

△ CP 1	SURVEY CONTROL POINT
•	FOUR-SURVEY MONUMENT
+3341.85	SPOT ELEVATION
⊙	BENCHMARK LOCATION
○	CLEAR CUT
○	CURB STOP
○	WATER VALVE
○	FIRE MOUNT
○	POWER POLE
○	LIGHT POLE
○	ELECTRIC METER
○	GAS METER
○	DRAIN SPOUT
○	SIGN
○	TREE (DECIDUOUS) #7/10/16 DIAMETER
○	SHRUB (DECIDUOUS)
○	WIRE FENCE
○	WOOD FENCE
○	CURB & GUTTER
○	WATER LINE
○	OVERHEAD POWER LINE
○	GAS LINE
○	SEWERY SEWER LINE
○	TELEPHONE LINE
○	CONTOUR (1')
○	CONTOUR (5')

PRINTED  
 SEP 27 2006  
 FMG Inc.

**NOTE: UNDESIGNED UTILITIES**  
 SHOWN ARE BASED ON FIELD LOCATIONS  
 PROVIDED BY SOUTH DAKOTA ONE CALL AND  
 WHERE POSSIBLE, FIELD VERIFICATION. EXISTING  
 AND LOCATION OF ACTUAL UTILITIES MAY VARY  
 FROM THIS MAP. CONTRACTOR MUST VERIFY  
 LOCATION OF ALL UTILITIES BEFORE EXCAVATION.

STORM SEWER MAINLINE  
 RM=3340.45  
 FL INVERT=3341.33  
 FL MSL=3338.73  
 FL 100'=3338.83  
 FL 200'=3338.63

STORM SEWER MAINLINE  
 RM=3339.84  
 FL INVERT=3339.89  
 FL MSL=3339.84  
 FL 100'=3339.74

TEMPORARY MONUMENT  
 BY CONTINUING IN  
 OF THE SURVEY  
 PL=3440.43

TYPE B MILET  
 IC=3345.25  
 PL=3339.55

TYPE B MILET  
 IC=3345.25  
 PL=3340.74

STORM SEWER MAINLINE  
 RM=3339.84  
 FL INVERT=3339.89  
 FL MSL=3339.84  
 FL 100'=3339.74

STORM SEWER MAINLINE  
 RM=3339.84  
 FL INVERT=3339.89  
 FL MSL=3339.84  
 FL 100'=3339.74