



MASTER UTILITY PLAN NOTES:  
 THIS SHEET IS ALSO BEING PROVIDED AS A "TYPICAL" REFERENCE FOR UTILITIES  
 EXISTING & INTEND BEING CONSTRUCTED.  
 NOTE THAT ALL UTILITIES MENTIONED ABOVE MAY NOT BE REFERENCED ON THIS SHEET  
 CONTRACTORS ARE TO USE THE PLAN & PROFILE SHEETS PROVIDED FOR CORRECT  
 INSTALLATION NOTES FOR ANY UTILITIES REFERENCED ON THIS SHEET  
 ALL WATER MAIN IS 8" C900-CL150 UNLESS OTHERWISE SPECIFIED.  
 ALL SANITARY SEWER MAIN IS 8" UNLESS OTHERWISE SPECIFIED.  
 STREET LIGHTS SHALL BE INSTALLED AT THE LOCATIONS SHOWN ON THIS PLAN AND  
 INSTALLED PER CITY OF BAKO CITY, PUBLIC WORKS DEPARTMENT, 2004 STANDARD  
 SPECIFICATIONS & STANDARD DETAILS.

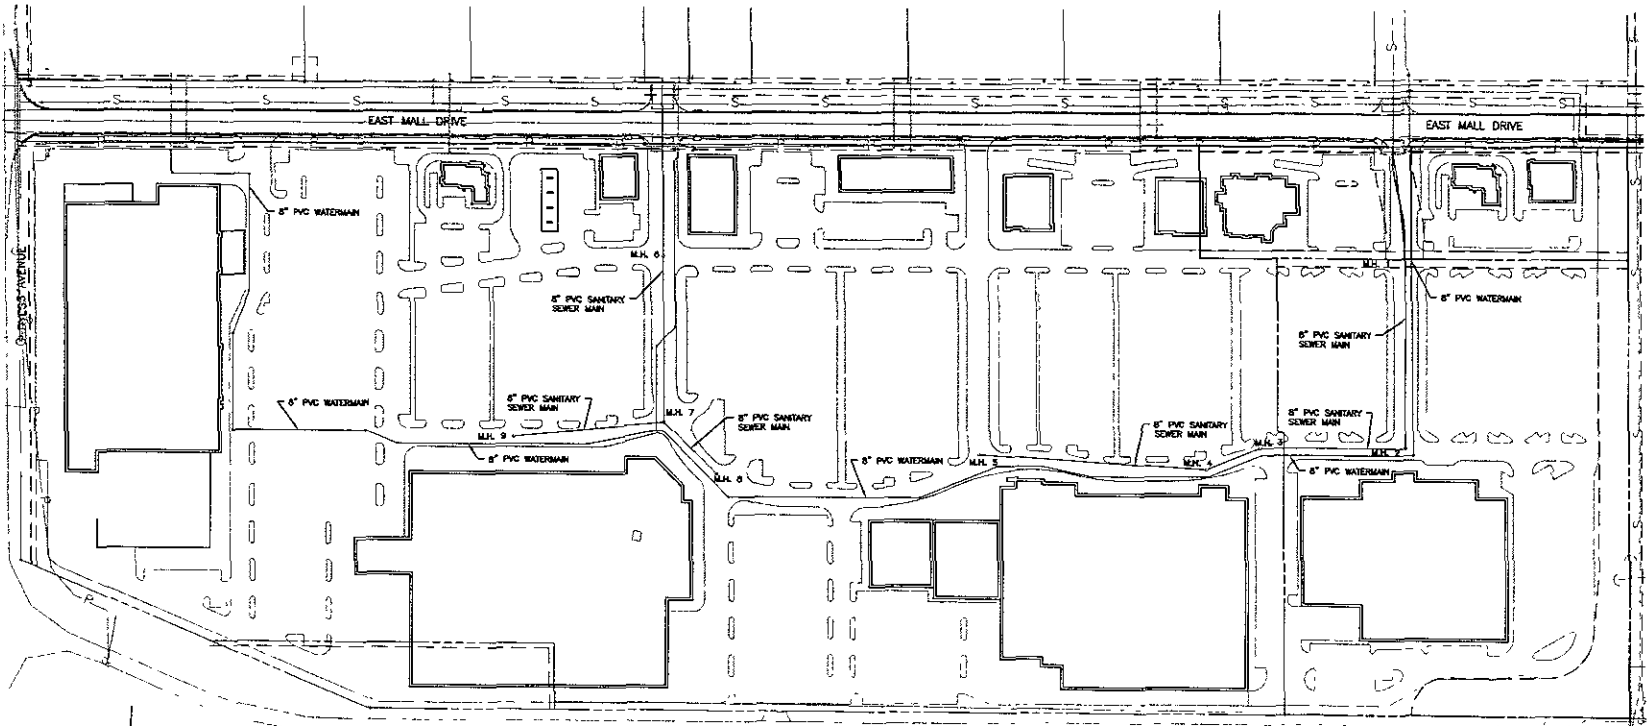

INTERSTATE 90

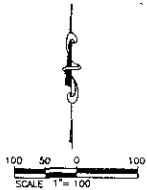

PRELIMINARY



PRELIMINARY FOR REVIEW ONLY

Drawn	AS NOTED
Checked By	AS
Design Date	06-07
Final Date	06-07
Project No.	07 PD046
Drawn By	ASLETH
Checked By	

RAPID CENTER