


- LEGEND**
- ⊕ = Sanitary Sewer Manhole (Unless noted)
 - ⊙ = Fire Hydrant
 - ⊖ = Water Valve
 - ⊕ = Utility Pole
 - = Guy Wire
 - = Wood Privacy Fence
 - = Wood Wire Fence
 - = Chain Link Fence
 - = Overhead Utility Line
 - = Sanitary Sewer Line
 - = Water Main
 - ⊕ = Found Survey Monument, LS 6599, or as noted
 - ⊙ = Set Rebar with cap marked "RW Flak 6562"
 - △ = Control Point

SURVEYOR'S NOTES

Utilities shown are from visual inspection, sketches provided by individual service providers and Utility Locates performed by South Dakota One Call, Ticket Number 07113223. The actual location of utilities and service lines may vary from the information shown hereon. We assume no liability for utilities and services that are not marked or are incorrectly defined by utility locators.

Bench Mark: STA 1200

ONE CALL
BEFORE DIGGING
1-800-781-7474

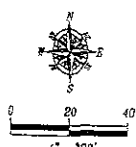

RECEIVED
 JUL 27 2007
 Rapid City, S.D.
 Management Dept.
 Planning & Zoning
 2800 DB




The information herein is for informational purposes only and does not constitute a contract. The user assumes all responsibility for the accuracy and completeness of the information herein. No warranty or guarantee is made by the engineer or architect for any part of or any other purpose of any project or work.

Site Plan
 Lot 3, Block 4, of
 Feigel Subdivision
 Section 31, T2N, R8E, B.H.M.
 Rapid City, Pennington County, South Dakota

Surveyed by R.W.F.
 Date 3/3/07
 Drawn by R.W.F.
 Date 3/7/07
 Checked by R.W.F.
 Revisions

Project No.
 07-05-01
 Sheet
 3

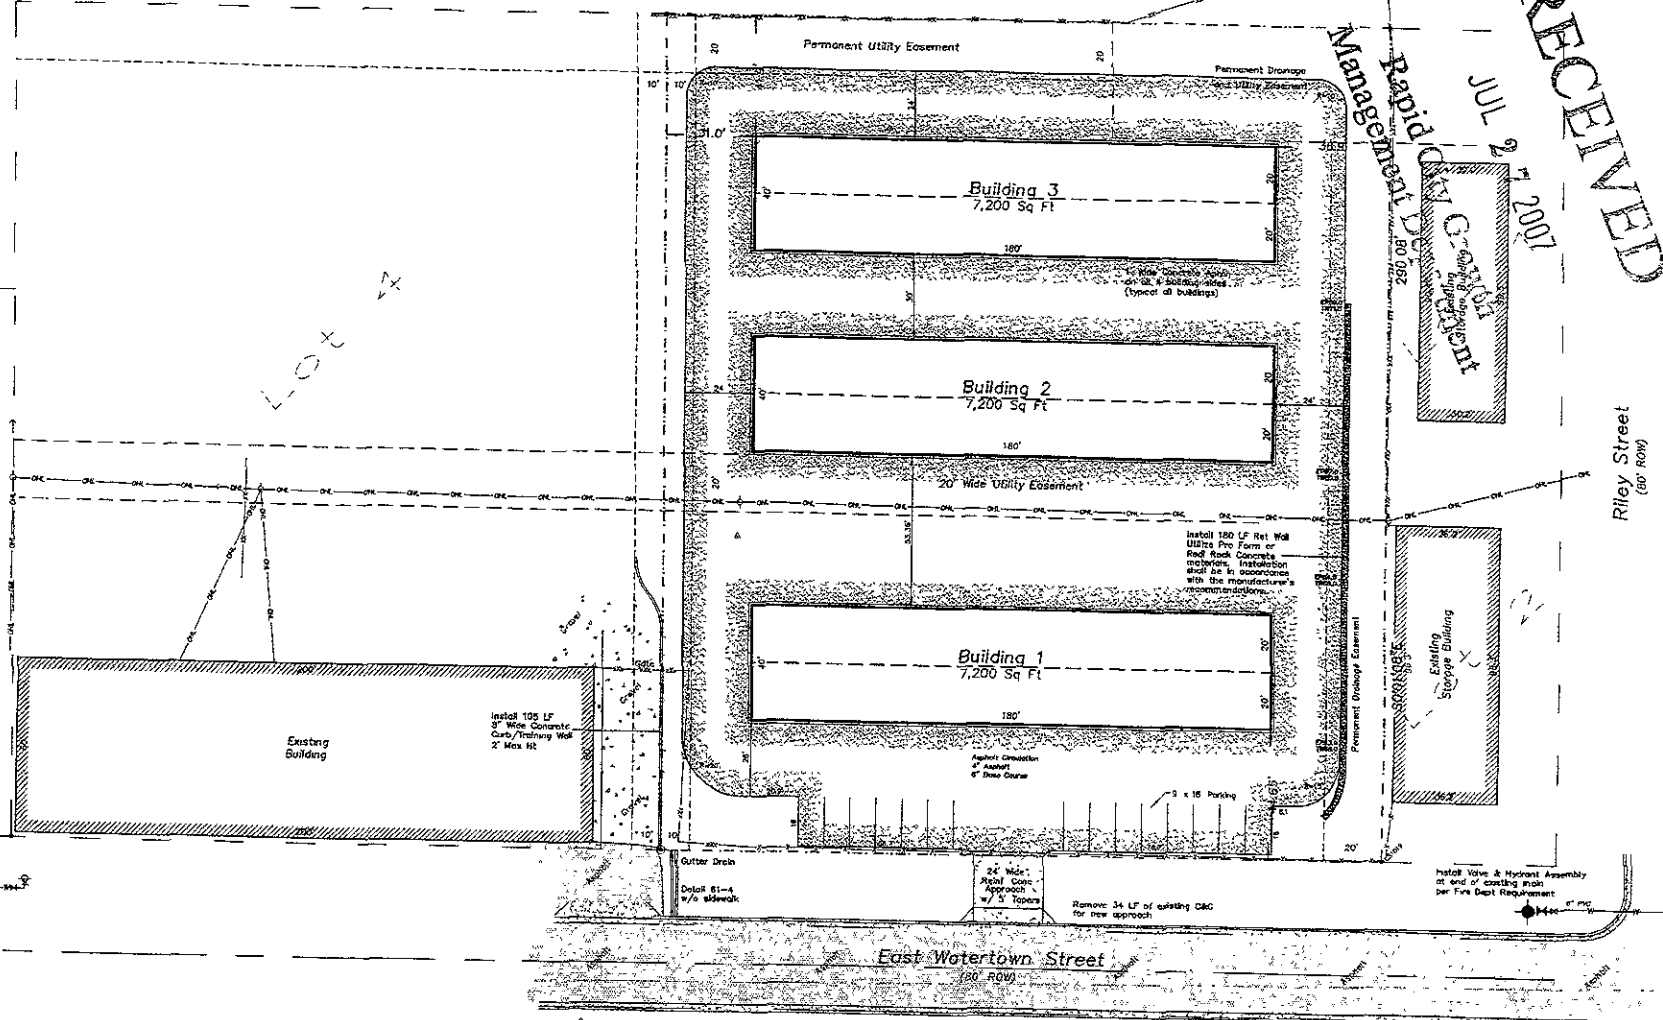

3253.36
INV. OUT

3246.73
INV. IN
3246.70
REV. OUT