


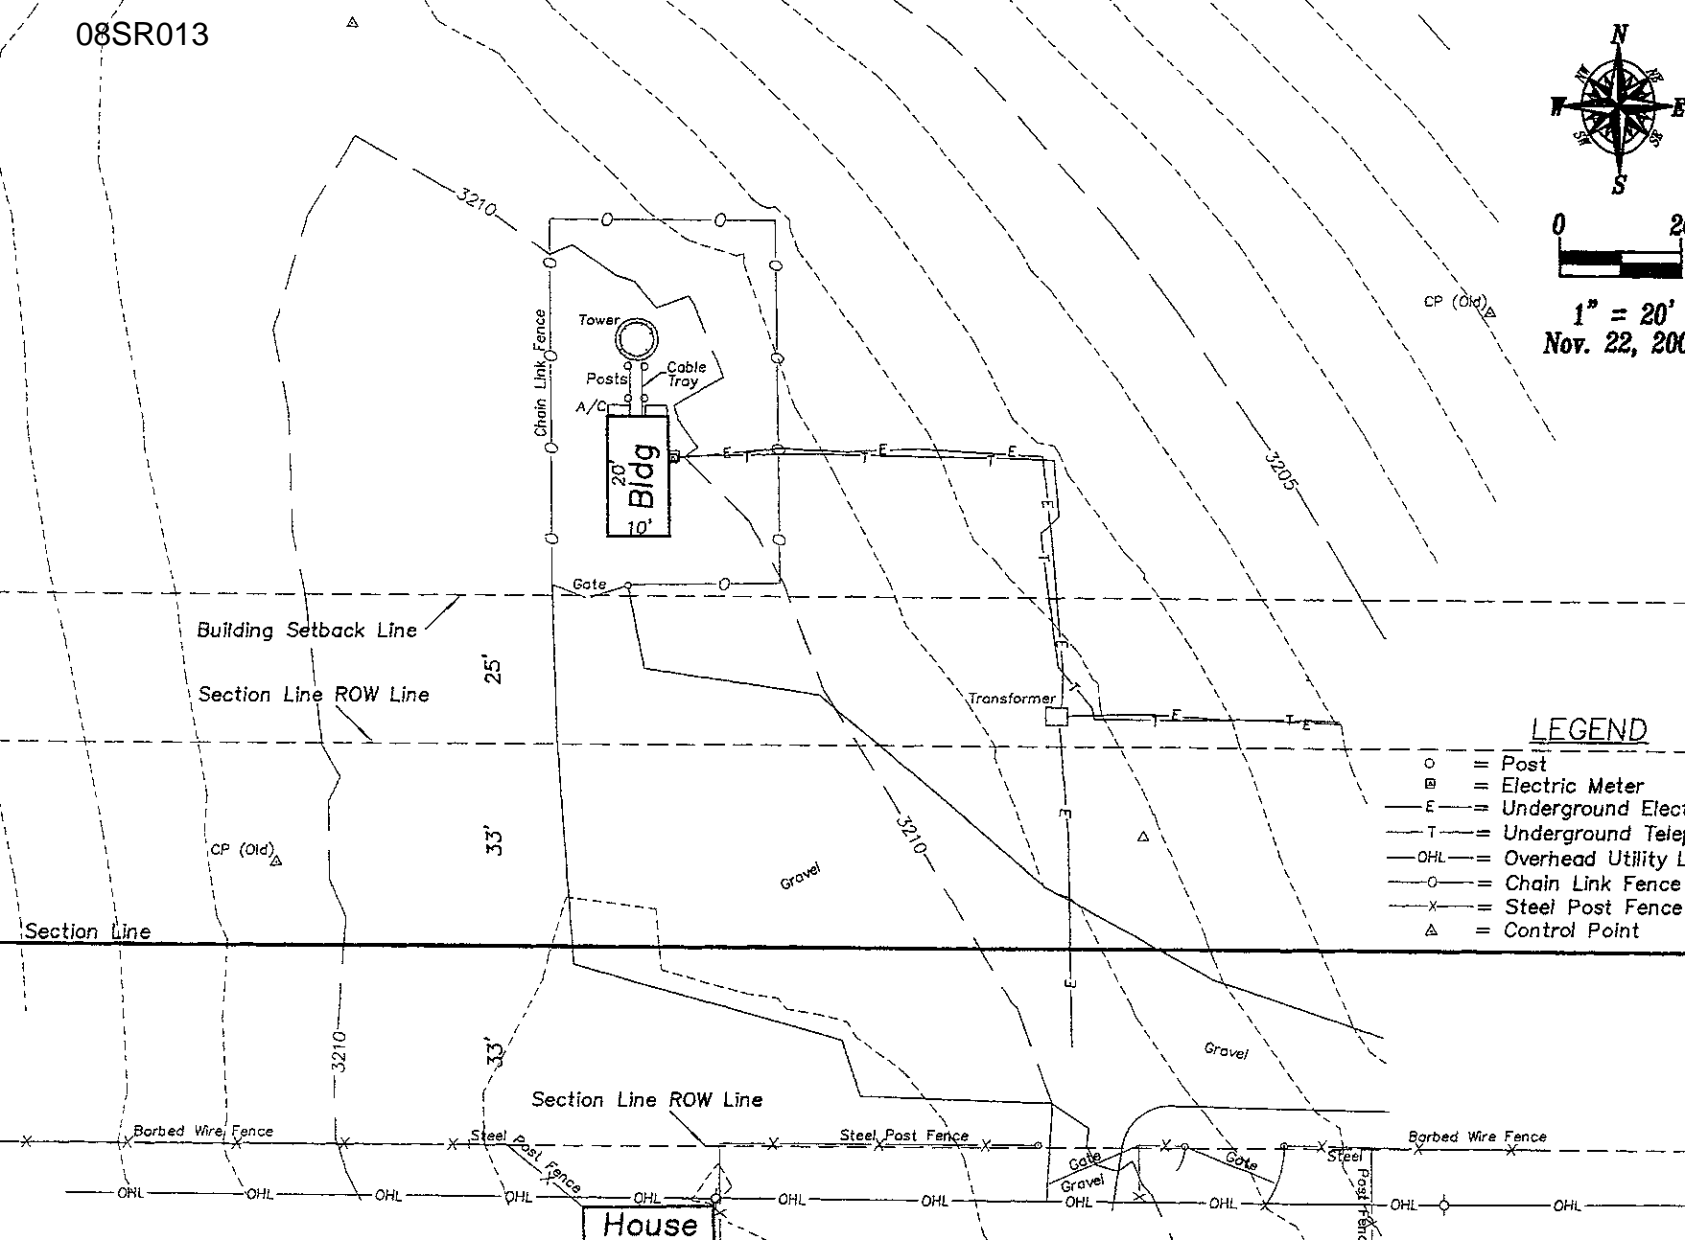

1" = 20'
Nov. 22, 2005



LEGEND

- = Post
- = Electric Meter
- F — = Underground Electric
- T — = Underground Telephone
- OHL — = Overhead Utility Line
- — = Chain Link Fence Line
- X — = Steel Post Fence Line
- △ = Control Point

Site Plan - RCYC SE Rapid City
 3019 S. Valley Drive
 Rapid City, South Dakota,

1022 Main Street
 P.O. Box #154
 Rapid City, South Dakota
 57702
 (605) 348-1538
 (605) 341-1117 (fax)

Fisk Land Surveying & Consulting Engineers, Inc.

| | |
|--------------|----------|
| Date | 11/10/05 |
| Surveyed by: | BLDR |
| Drawn by: | LAR |
| Checked by: | RWF |
| Revisions | |
| Project No. | 05-10-06 |