




Sep 18, 2008 - 3:12pm - G:\Landscape Architecture\Projects\PR08-1740 Robinsdale Park Field Access Trail\500 Drawings\503 Working Drawings\1740_Site Plan_08-08-08.dwg

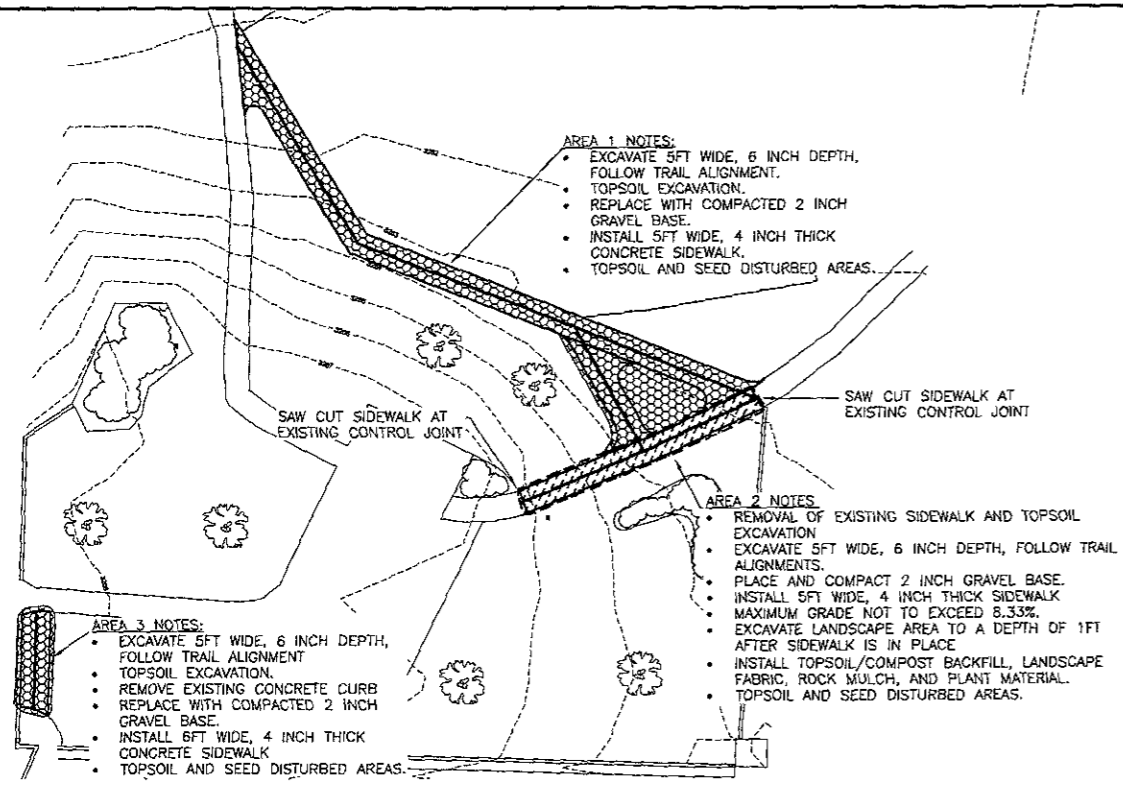

DEMOLITION PLAN
SCALE = 1" = 20'

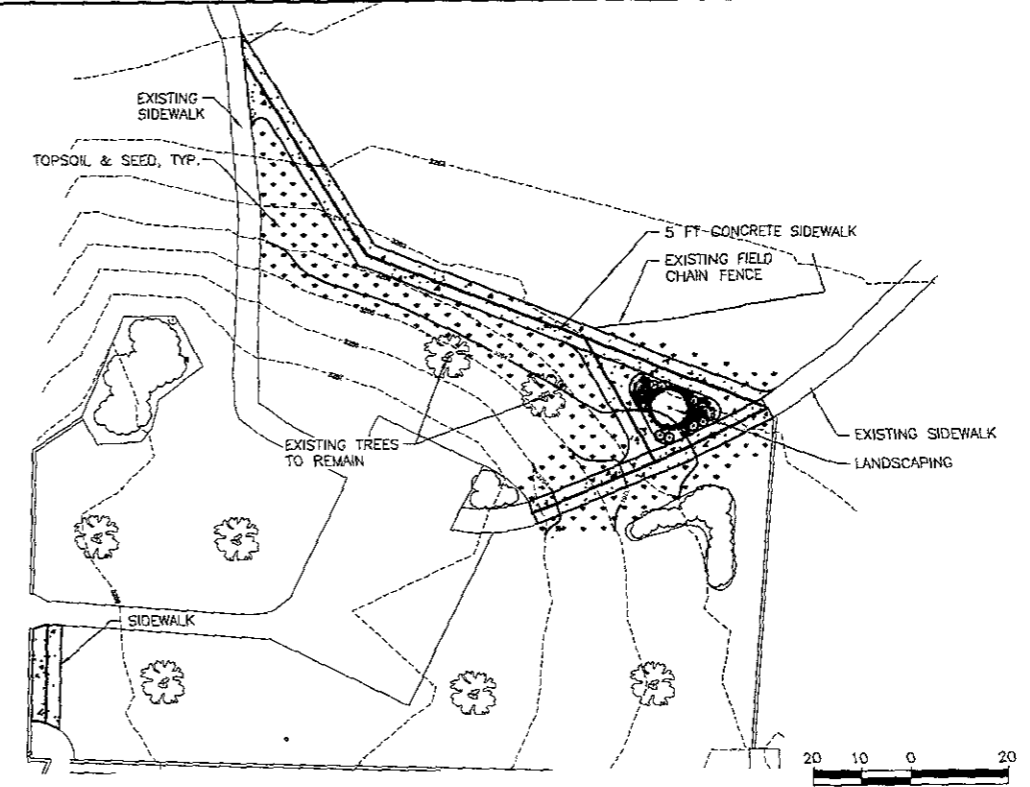


SITE PLAN
SCALE: 1" = 20'

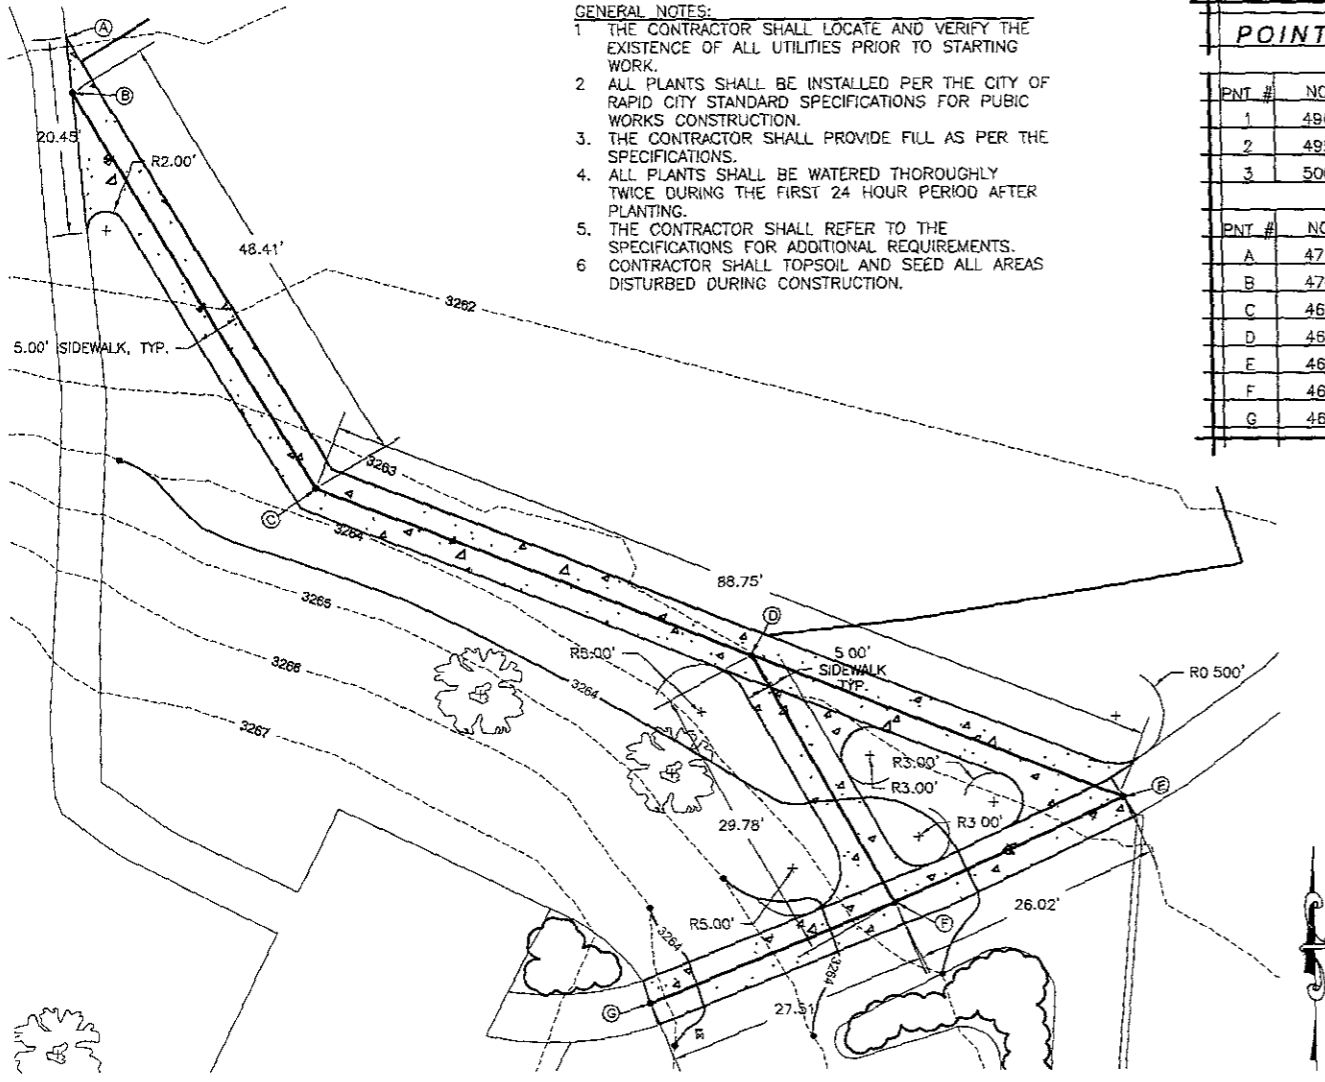

LAYOUT PLAN
SCALE = 1" = 10'

- GENERAL NOTES:**
1. THE CONTRACTOR SHALL LOCATE AND VERIFY THE EXISTENCE OF ALL UTILITIES PRIOR TO STARTING WORK.
 2. ALL PLANTS SHALL BE INSTALLED PER THE CITY OF RAPID CITY STANDARD SPECIFICATIONS FOR PUBLIC WORKS CONSTRUCTION.
 3. THE CONTRACTOR SHALL PROVIDE FILL AS PER THE SPECIFICATIONS.
 4. ALL PLANTS SHALL BE WATERED THOROUGHLY TWICE DURING THE FIRST 24 HOUR PERIOD AFTER PLANTING.
 5. THE CONTRACTOR SHALL REFER TO THE SPECIFICATIONS FOR ADDITIONAL REQUIREMENTS.
 6. CONTRACTOR SHALL TOPSOIL AND SEED ALL AREAS DISTURBED DURING CONSTRUCTION.

POINT SCHEDULE			
CONTROL POINTS			
PNT #	NORTHING	EASTING	ELEVATION
1	4860.8023	4635.9391	3257.3900
2	4954.3788	4824.1825	3258.7400
3	5000.0000	5000.0000	3258.4100
CONSTRUCTION POINTS			
PNT #	NORTHING	EASTING	
A	4712.0416	4647.5843	-
B	4706.2545	4648.1998	-
C	4664.9821	4673.5029	-
D	4647.5192	4718.4049	-
E	4632.5178	4756.5692	-
F	4621.5458	4732.9803	-
G	4611.0829	4707.5371	-

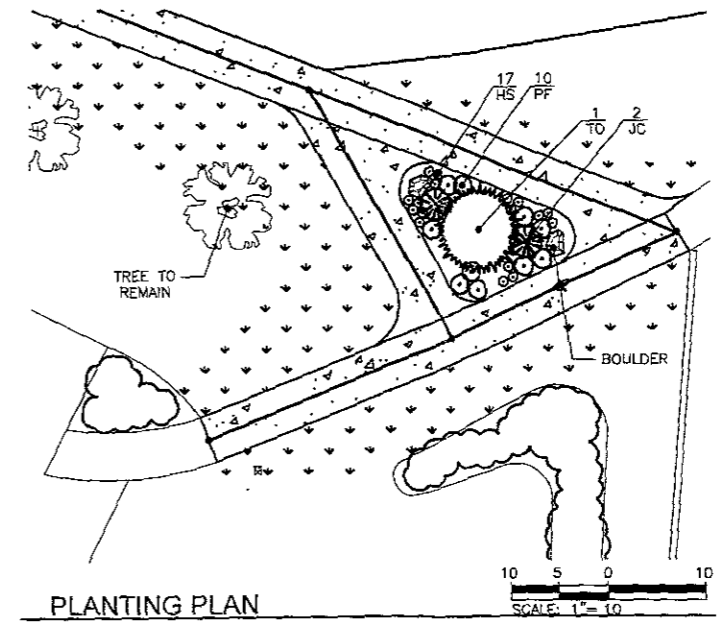

PLANTING PLAN
SCALE: 1" = 10'

PLANT SCHEDULE					
SYMBOL	QNTY	COMMON NAME	BOTANICAL NAME	SIZE	NOTES
CONIFEROUS TREES					
TO	1	TECHNY ARBORVITEA	THUGA OCCIDENTALIS 'TECHNY'	6 ft.	-
DECIDUOUS SHRUBS					
PF	10	GOLDFINGER POTENILLA	POTENTILLA FRUTICOSA 'GOLDFINGER'	5 gallon	-
CONIFEROUS SHRUBS					
JC	2	MINT JULEP JUNIPER	JUNIPERUS CHINENSIS 'MINT JULEP'	5 gallon	-
HERBACEOUS PLANTS & GRASSES					
HS	17	BLUE OAT GRASS	HELICOTRICHON SEMPERVIRENS	2 gallon	-
SEEDING					
	190sq	PER CITY SPECIFICATIONS	PER CITY SPECIFICATIONS	SIZE	-
MISCELLANEOUS					
	2	BOULDER	BOULDER	2 - 4 ft.	-



CITY OF RAPID CITY
LANDSCAPE ARCHITECTURE
PARKS & RECREATION

Scale: 1" = 20'
Designed By: RLL
Drawn By: RLL
Design Date: AUG - 2008
Print Date: 9/18/08
Internal Job No:
Surveyed By: RG
Survey Date:
Revisions:

Robinsdale Park - Trail Expansion
Rapid City, South Dakota