

Prepared By



DREAM DESIGN
INTERNATIONAL, INC.
1000 14th Street, Suite 100
Rapid City, SD 57701
Phone: 605.343.1111
Fax: 605.343.1112
www.dreamdesigninc.com

**PRELIMINARY
FOR REVIEW ONLY**

CITY OF RAPID CITY
GROWTH MANAGEMENT DEPT
DEVELOPMENT SERVICES

Plans are intended for general information only and are not to be used for construction. The City of Rapid City does not warrant the accuracy, reliability, or completeness of the plans or specifications. All necessary permits shall be obtained prior to construction of the proposed public improvements.

Engineering Review	Date	
Checked		
Submitted		
Reviewed Job No.	Designed By	Drawn By
060205	TC	JG/SL
Formed By	Survey Date	
REISNER & ASSOCIATES	06/2006	
Submitted		

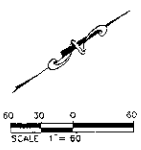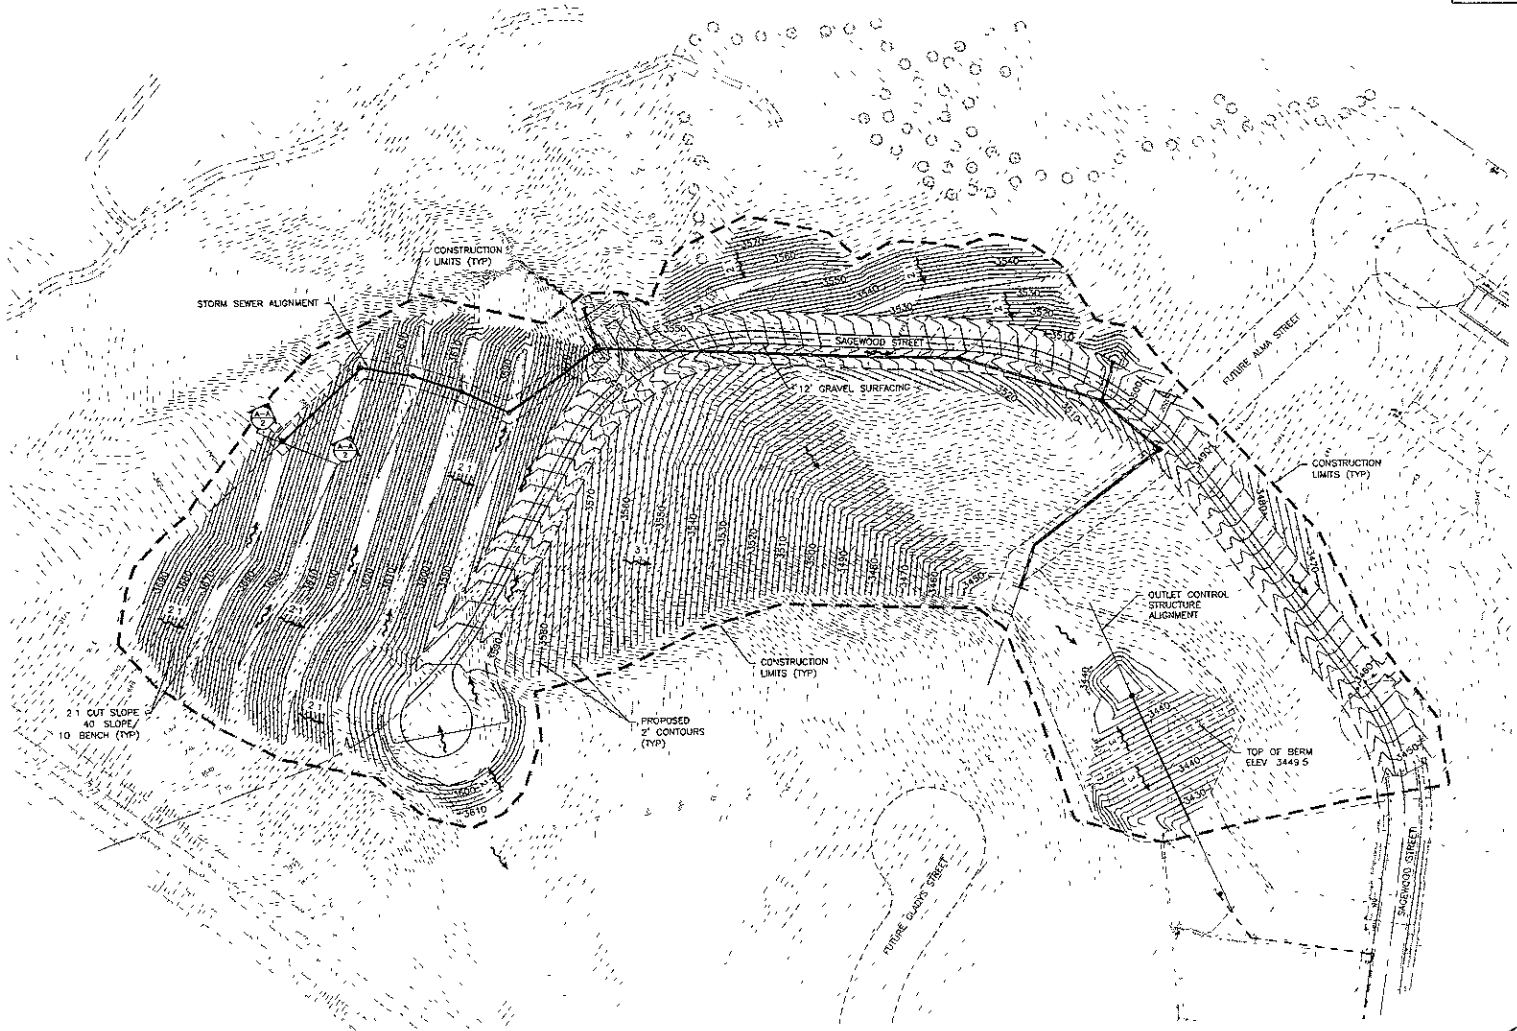

**RAINBOW RIDGE
WATER MAIN EXTENSION**

MASTER GRADING PLAN