


1 SITE PREPARATION LAYOUT
SCALE: 1/4"=1'-0"

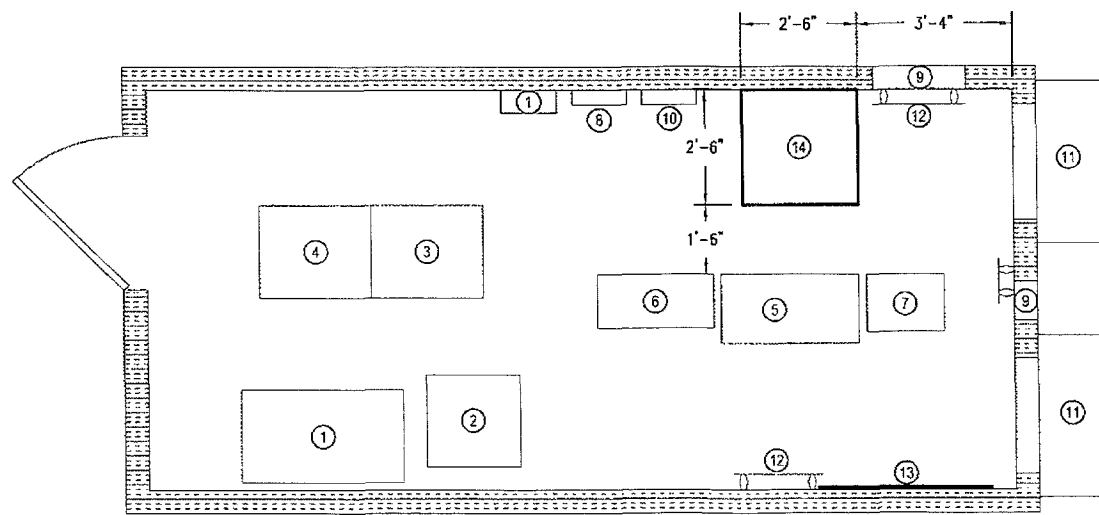

2 PROPOSED EQUIPMENT LAYOUT
SCALE: 1/4"=1'-0"

EQUIPMENT LEGEND:

- ① EXISTING BATTERY RACK
- ② EXISTING 24V DC POWER PLANT
- ③ EXISTING CDMA RACK #1
- ④ EXISTING CDMA RACK #2
- ⑤ EXISTING GSM RACK #1
- ⑥ EXISTING GSM RACK #2
- ⑦ EXISTING TELCO RACK
- ⑧ EXISTING AC BREAKER PANEL
- ⑨ EXISTING TELCO PORT
- ⑩ EXISTING SAFETY SWITCH
- ⑪ EXISTING HVAC UNIT
- ⑫ EXISTING GROUND BAR
- ⑬ EXISTING TELCO BOARD
- ⑭ PROPOSED LUCENT NODE-B




GENERAL DYNAMICS
Wireless Services



SSOE, INC.
ARCHITECTS • ENGINEER
SSOE PROJECT# 009-00982-00

THE INFORMATION CONTAINED IN THIS SET OF DOCUMENTS IS PROPRIETARY BY NATURE. ANY USE OR DISCLOSURE OTHER THAN THAT WHICH RELATES TO THE CLIENT IS STRICTLY PROHIBITED.

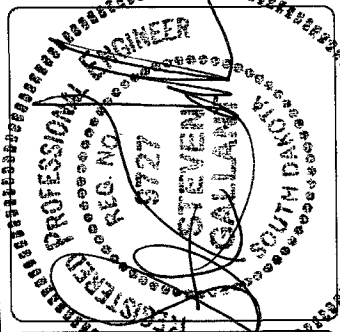

SITE NAME:	RAPID CITY
SITE NUMBER:	132000896
SITE COORDINATES:	LAT: 44.08650 LON: -103.189
SITE ADDRESS:	1437 E. PHILADELPHIA RAPID CITY, SD 57703
DESIGN TYPE:	SITE LAYOUT

A&E PROJECT #:	009-00982-00
DRAWN BY:	MH
CHECKED BY:	FW

REVISIONS		
NO.	DATE	DESCRIPTION
0	07/13/10	SITE LAYOUT

SHEET TITLE:
COMPOUND & EQUIPMENT LAYOUT

DRAWING NO.	REVISION:
C-1	0