

### TYPE "A & C"

**LITHONIA LIGHTING**

**Area Lighting**  
**KSE2**

**FEATURES & SPECIFICATIONS**

**DESCRIPTION:** The KSE2 is a recessed, square, surface-mount lighting fixture. It is designed for use in commercial and residential applications. The fixture is made of die-cast aluminum and is finished with a powder-coated finish. It is available in two sizes: 12" x 12" and 18" x 18". The fixture is designed to be recessed into a ceiling and is suitable for use in areas with high ceilings. The fixture is designed to be dimmable and is compatible with most dimmers. The fixture is designed to be easy to install and is suitable for use in areas with high ceilings. The fixture is designed to be easy to install and is suitable for use in areas with high ceilings.

**ORDERING INFORMATION**

Example: KSE2-400M-R3 120 SCNA 57W 12" UP

Symbol	Label	Qty	Coloring Number	Description	Notes
A	KSE2-400M-R3	1	120	120 SCNA 57W 12" UP	

### TYPE "A & C"

**KSE2 Premium Cutoff Lighting**

**ILLUMINANCE PLOT (Footcandle)**

**Notes:**

1. Footcandle data for one fixture, including data for a 10' x 10' room.
2. For additional information, contact your local distributor.
3. For additional information, contact your local distributor.
4. For additional information, contact your local distributor.

**ILLUMINANCE PLOT (Footcandle)**

**Notes:**

1. Footcandle data for one fixture, including data for a 10' x 10' room.
2. For additional information, contact your local distributor.
3. For additional information, contact your local distributor.
4. For additional information, contact your local distributor.

**LITHONIA LIGHTING**

### TYPE "B"

**INVUE**

**DESCRIPTION:** The INVUE is a recessed, square, surface-mount lighting fixture. It is designed for use in commercial and residential applications. The fixture is made of die-cast aluminum and is finished with a powder-coated finish. It is available in two sizes: 12" x 12" and 18" x 18". The fixture is designed to be recessed into a ceiling and is suitable for use in areas with high ceilings. The fixture is designed to be dimmable and is compatible with most dimmers. The fixture is designed to be easy to install and is suitable for use in areas with high ceilings.

**ORDERING INFORMATION**


Example: INVUE-400M-R3 120 SCNA 57W 12" UP

**ILLUMINANCE PLOT (Footcandle)**

**Notes:**

1. Footcandle data for one fixture, including data for a 10' x 10' room.
2. For additional information, contact your local distributor.
3. For additional information, contact your local distributor.
4. For additional information, contact your local distributor.

**LITHONIA LIGHTING**

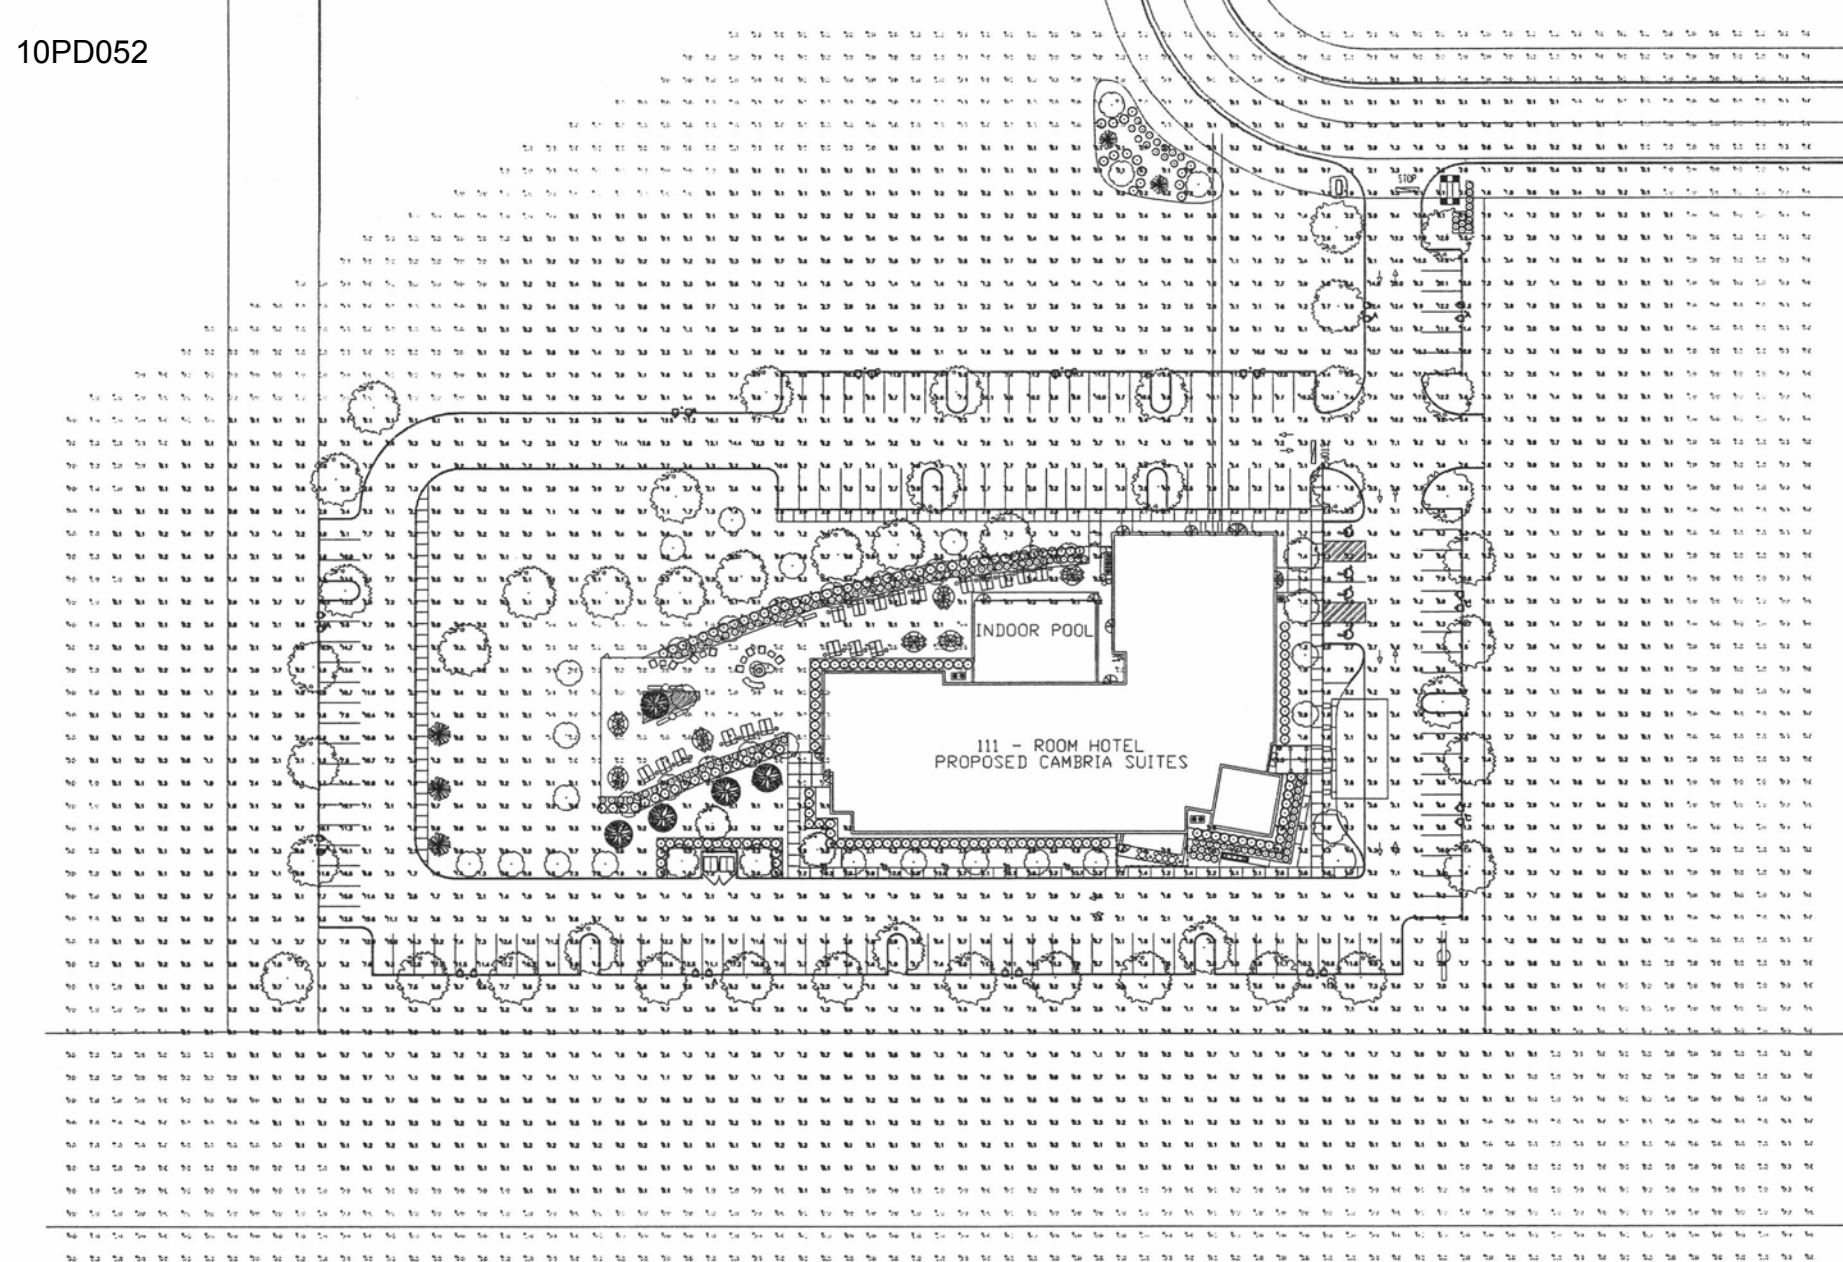

### TYPE "B"

**DESCRIPTION:** The INVUE is a recessed, square, surface-mount lighting fixture. It is designed for use in commercial and residential applications. The fixture is made of die-cast aluminum and is finished with a powder-coated finish. It is available in two sizes: 12" x 12" and 18" x 18". The fixture is designed to be recessed into a ceiling and is suitable for use in areas with high ceilings. The fixture is designed to be dimmable and is compatible with most dimmers. The fixture is designed to be easy to install and is suitable for use in areas with high ceilings.

**ORDERING INFORMATION**

Example: INVUE-400M-R3 120 SCNA 57W 12" UP

**ILLUMINANCE PLOT (Footcandle)**

**Notes:**

1. Footcandle data for one fixture, including data for a 10' x 10' room.
2. For additional information, contact your local distributor.
3. For additional information, contact your local distributor.
4. For additional information, contact your local distributor.

**LITHONIA LIGHTING**

### SITE PLAN - PHOTOMETRIC PLAN

SCALE: 1" = 30'-0"

**LUMINAIRE SCHEDULE**

Symbol	Label	Qty	Coloring Number	Description	Lamp	File	Lumens	LLF	Watts	Overall Height
A	KSE2-400M-R3 (PULSE START)	7	120	PREMIUM CUTOFF SHOULDER WITH SEGMENTED REFLECTOR MEETS THE NIGHTTIME FRIENDLY CRITERIA	ONE 400 WATT CLEAR EDIS PULSE START METAL HALIDE BI HORIZONTAL POSITION	KSE2_400M_R3_PULSE_START	38000	0.81	912	24'-0"
B	INVUE-100-180-180	6	120	ARCHITECTURAL BOLLARD	180 WATT MP COATED ED-17	INVUE-100-180-180	7900	0.81	100	-
C	KSE2-400M-R3V (PULSE START)	7	120	ARM MOUNTED PREMIUM CUTOFF SHOULDER WITH SEGMENTED REFLECTOR MEETS THE NIGHTTIME FRIENDLY CRITERIA	ONE 400 WATT CLEAR EDIS PULSE START METAL HALIDE BI HORIZONTAL POSITION	KSE2_400M_R3V_PULSE_START	38000	0.81	912	24'-0"

**STATISTICS**

Description	Symbol	Avg	Max	Min	MaxMin	AvgMin
Cell Zone #1	+	1.8 fc	20.7 fc	0.0 fc	N/A	N/A
Drop/Parking	X	8.3 fc	20.1 fc	0.0 fc	22.31	6.91
Walkway	X	4.4 fc	20.7 fc	1.2 fc	17.31	3.71

**EXCEL ENGINEERING**

160 CAMELOT DRIVE  
RICHMOND, VA 23135  
PHONE: 828-335-9600  
FAX: 828-335-9601

Always a Better Plan

**OWNER:**  
PROJECT: PROPOSED CAMBRIA SUITES  
RAPID CITY, SOUTH DAKOTA

**PRELIMINARY PLAN DATE:**  
AUGUST 11, 2010

**DATE:** 8-11-10  
**JOB NUMBER:** 1004050  
**SHEET**

**PXP**

PRELIMINARY DRAWING - NOT FOR CONSTRUCTION