
 
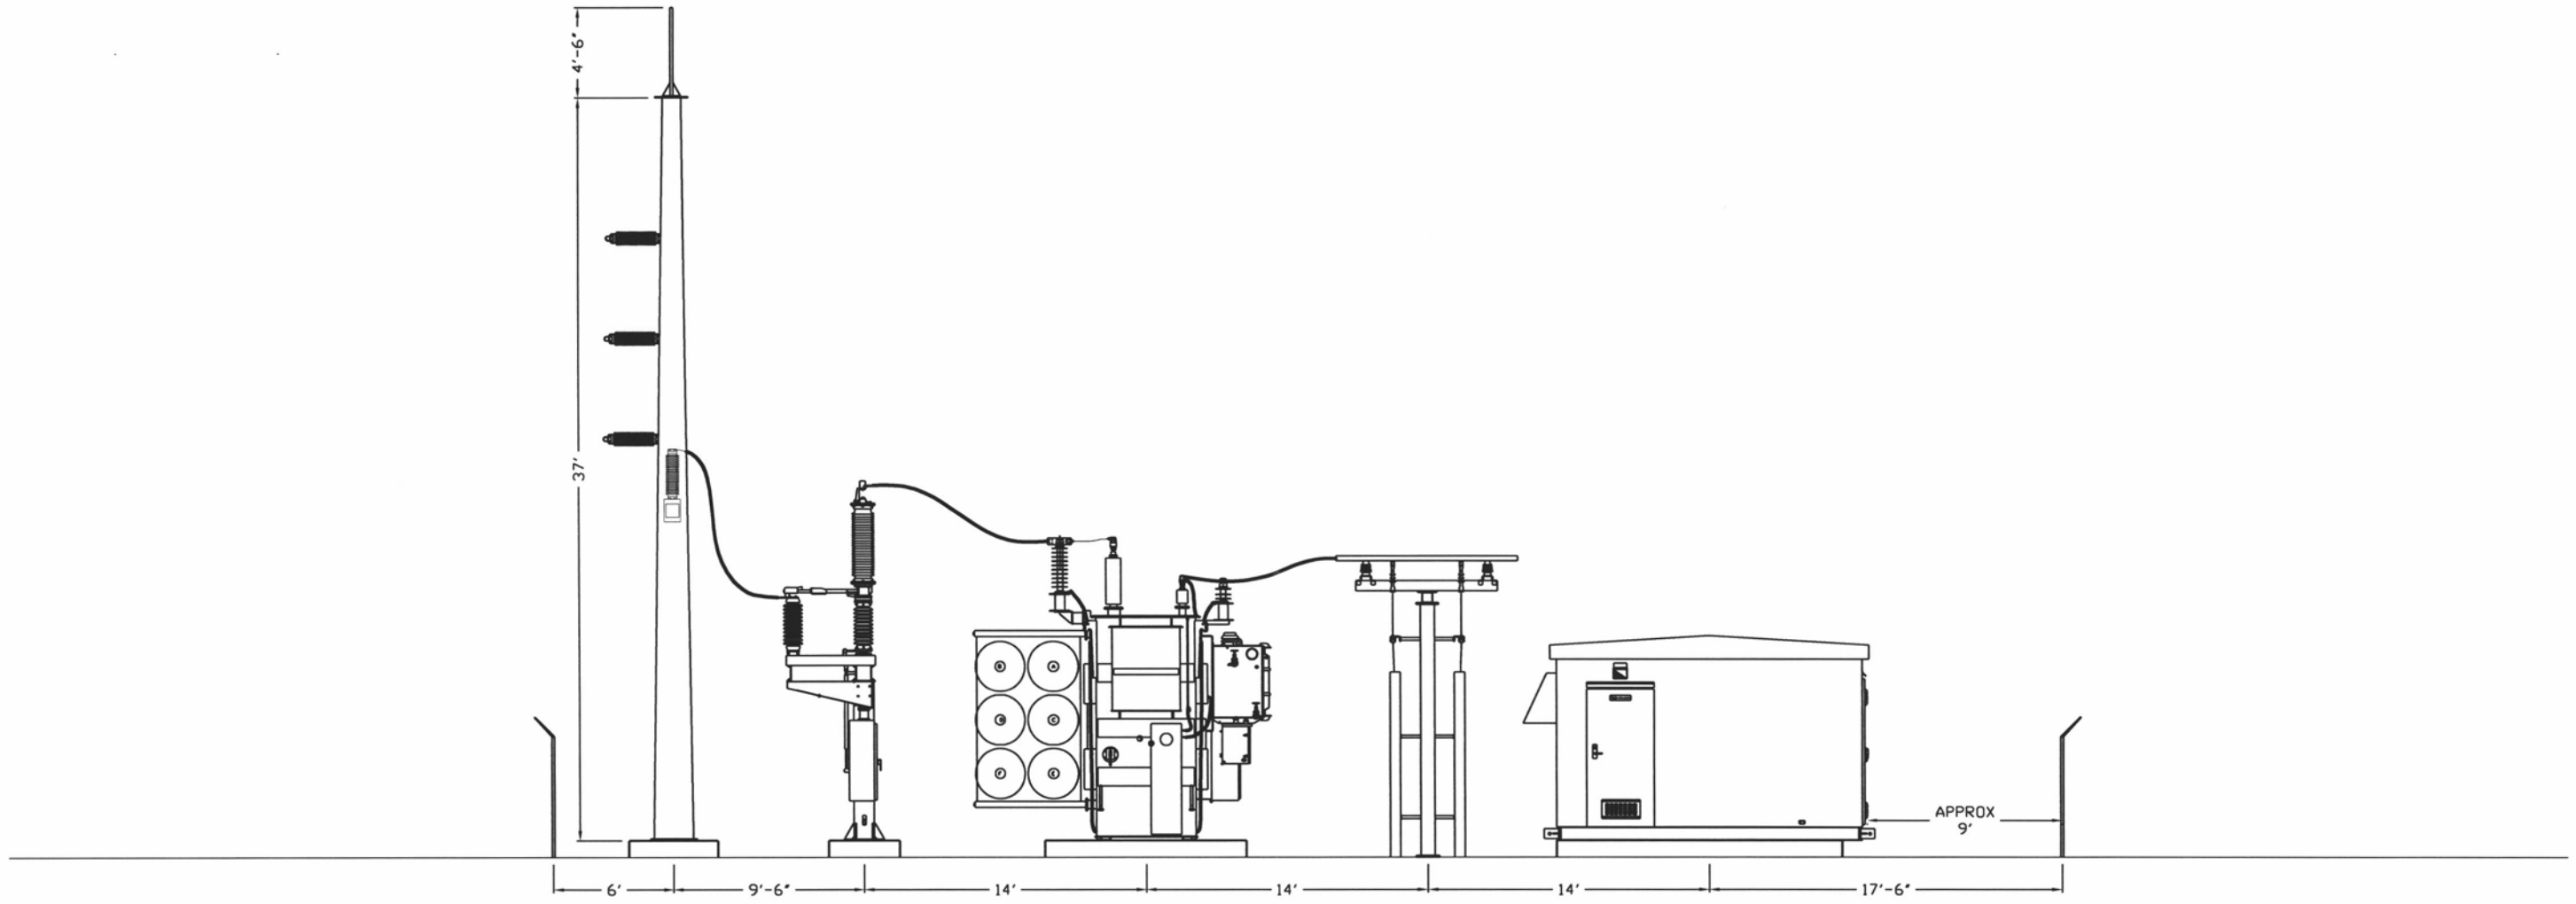



12UR015

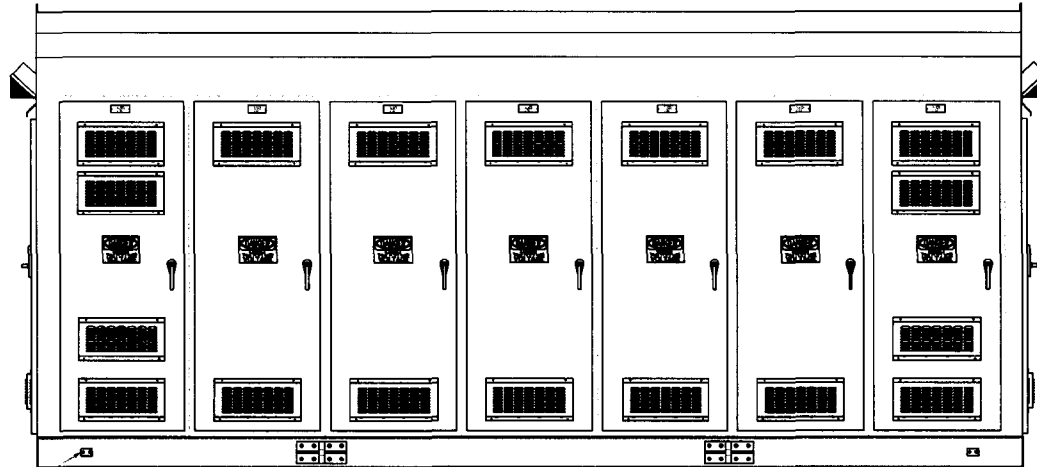

					<b>BLACK HILLS POWER</b>		
					FIFTH STREET SUBSTATION		
					<b>PLAN VIEW</b>		
DATE	DRAWN BY	NO.	APPROVED BY	REVISION DESCRIPTION	DESIGNED BY	DATE	DWG NO.
					S.D.	02/16/12	FIF-C-003
							0

12UR015

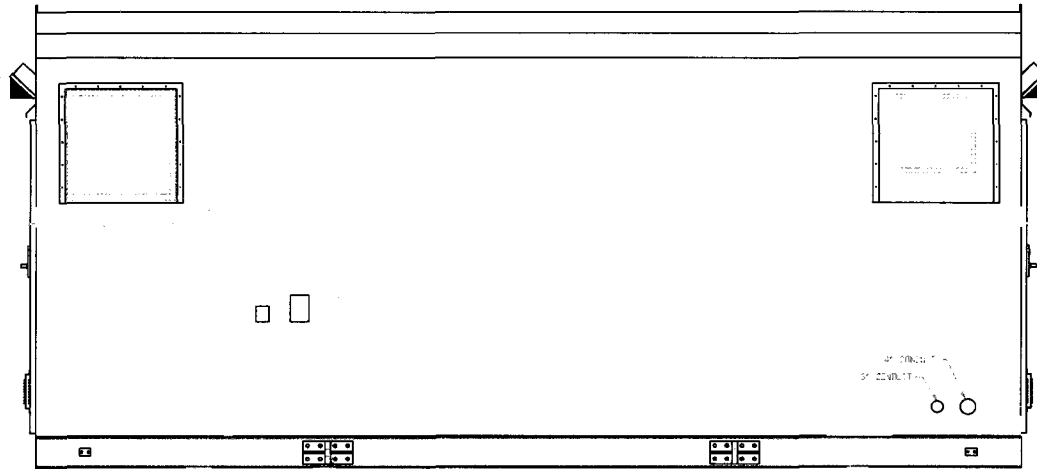

2 HOLE 5/8" DIA  
TOP - ALL 4 CORNERS

**RECEIVED**  
 JUN 12 2012  
**RAPID CITY COMMUNITY PLANNING  
 & DEVELOPMENT SERVICES**  
 Relay and Communications  
 Enclosure Details

SEE INCREASED BILL OF MATERIAL ITEM NUMBER

DATE	BY	REVISION	QTY	UNIT	DESCRIPTION
11/24/11	REVISED FOR CUSTOMER REQUEST	1	1	EA	
12/01/11	REVISED FOR BILL	2	1	EA	

<b>HAZZ   CENTRAL ELECTRIC</b>		CENTRAL ELECTRIC MANUFACTURING COMPANY 700 S. 15TH ST. P.O. BOX 10187 SIOUX FALLS, SD 57101	
CUSTOMER: BLACK HILLS CORPORATION FIFTH STREET SUBSTATION, RAPID CITY, SD 13 MI., 500 HWY., 2000A METAL-CLAD CUSTOMER P.O. NO. 5010002899			
DRAWING TITLE: FRONT & REAR EXTERIOR ELEVATIONS			
DRAWING BY: Approved for Production 12/1/2011	DESIGNED BY: H. Mohl CHECKED BY: C. Moller APPROVED BY: S. Moller	DATE: 12/1/2011	DRAWING NO: C8209M04