


LEGEND

- ⊙ = Sanitary Sewer Manhole (Unless noted)
- CS = Curb Stop
- = Utility Pole
- ⊗ = Light Pole
- ↑ = Guy Wire
- ⊥ = Sign
- MB = Mail Box
- X— = Fence Line
- OHL— = Overhead Utility Line
- T— = Overhead Communications
- SS— = Sanitary Sewer Line
- = Found Survey Monument
LS 4224 or as noted
- △ = Control Point

NOTE: Trunk Line Sewer Main connectivity not confirmed.
Further design shall warrant confirmation of main location and manhole connectivity.

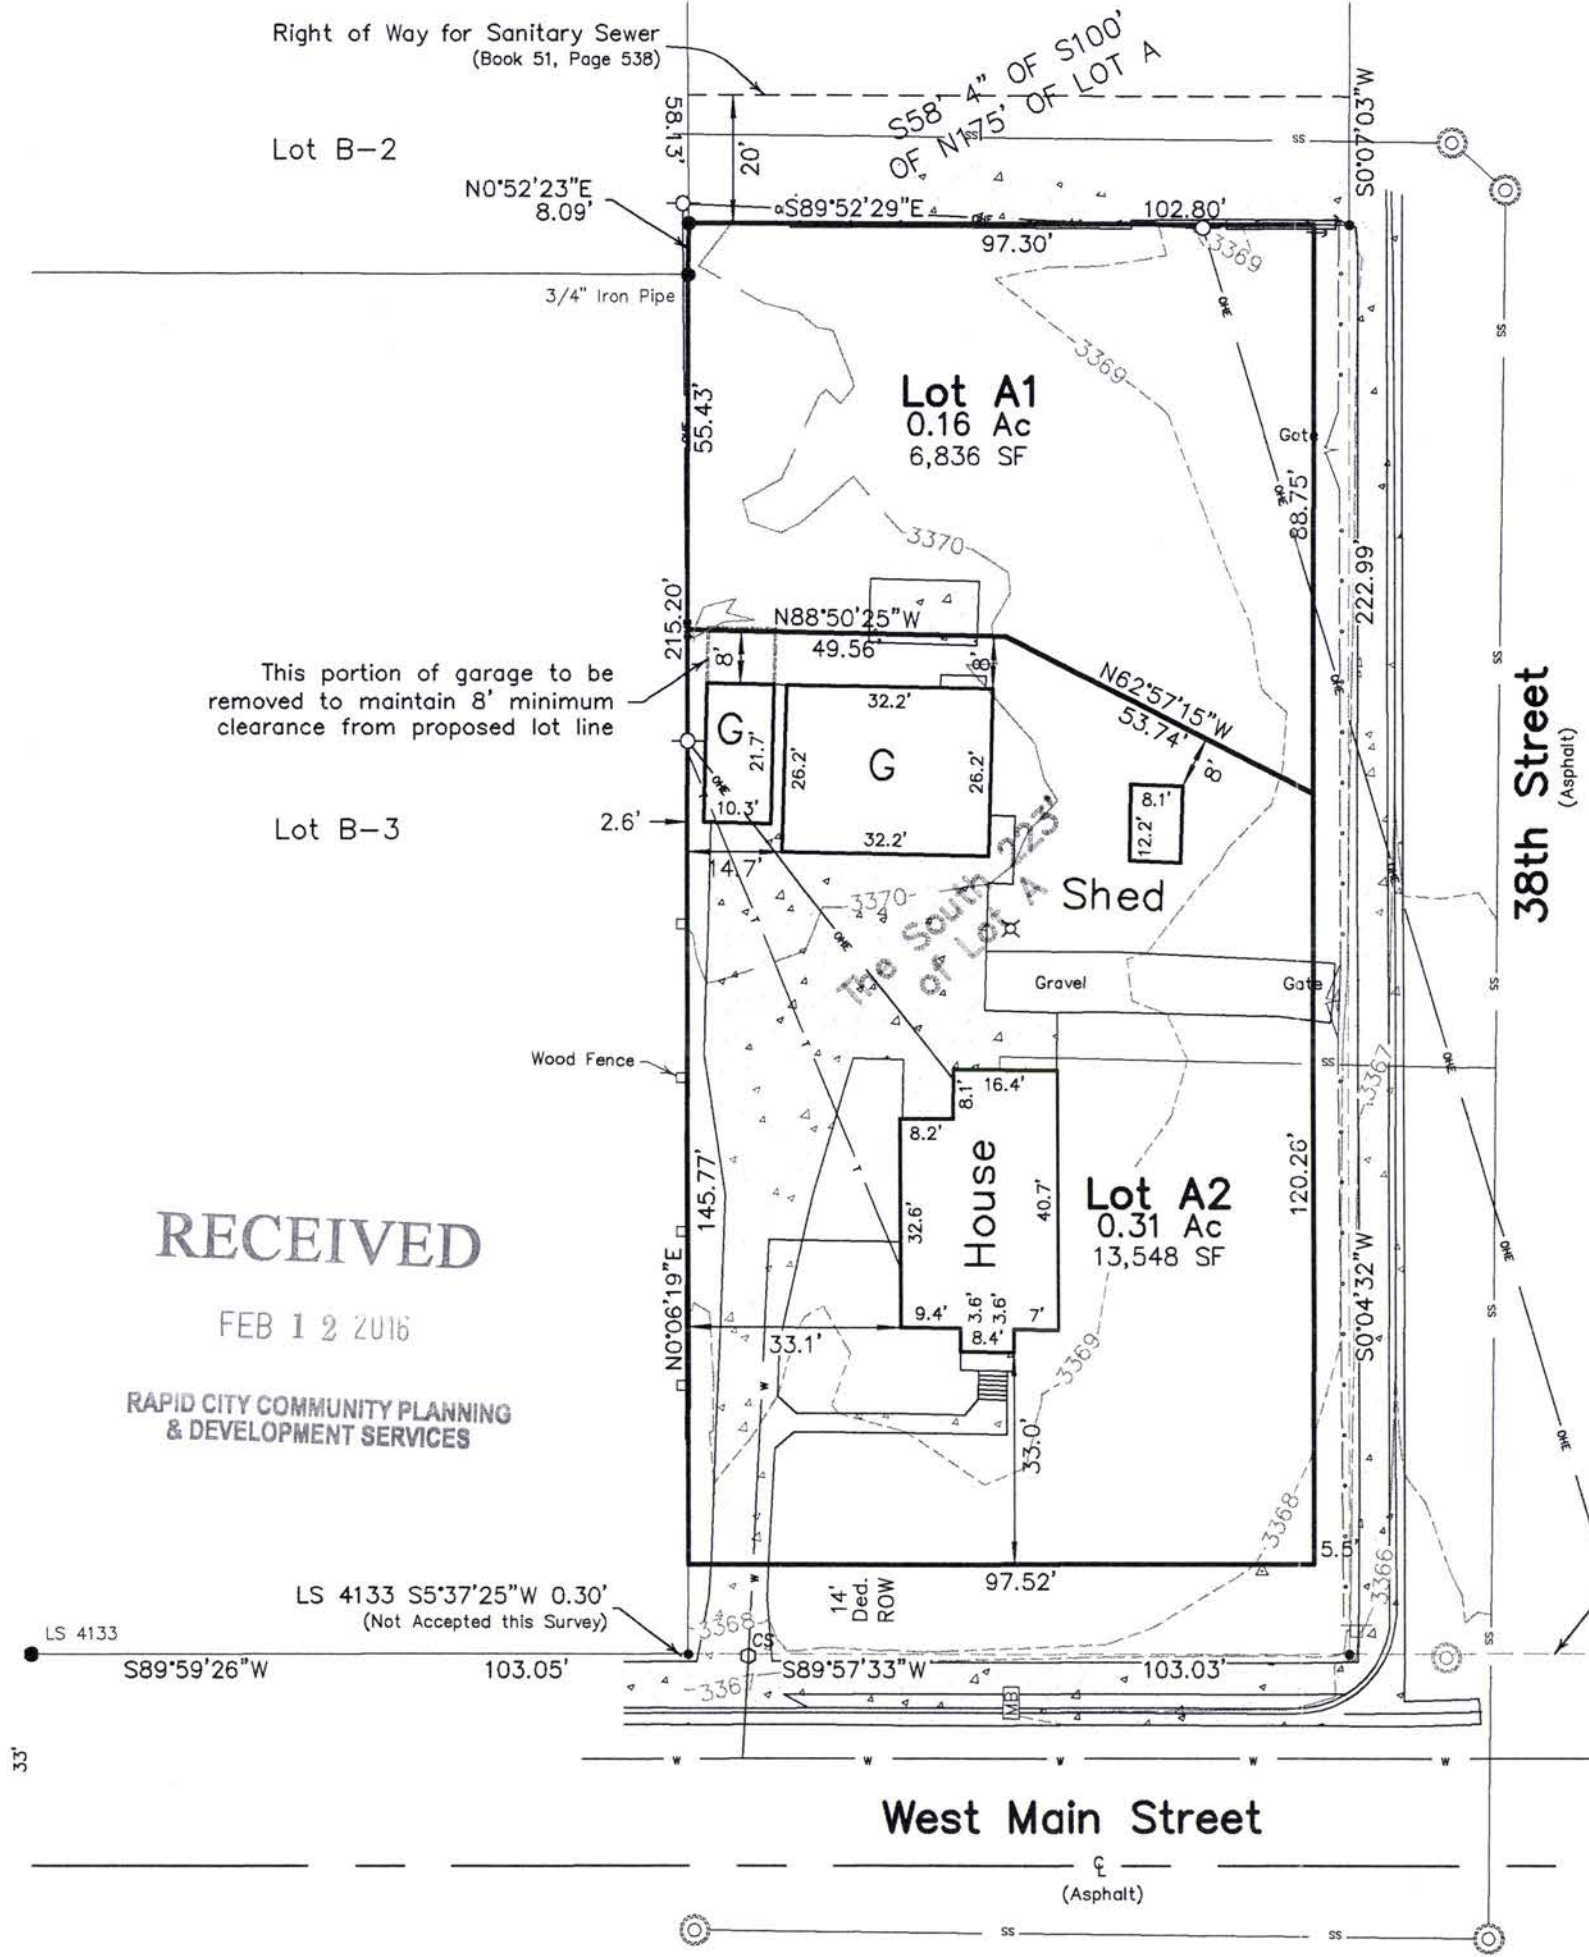

PRELIMINARY

Fisk Land Surveying
& Consulting, Inc.
Engineers, Inc.
1022 Main Street (P.O. Box 8154)
Rapid City, South Dakota 57709
(605) 348-1538
(605) 341-1112 (fx)

Topographic Survey / Site Plan
Proposed Lots A1 and A2,
East 10 Acres Subdivision, Rapid City,
Pennington County, South Dakota

Surveyed by:	ML,CD
Date	1/30/2015
Drawn by:	CDD
Checked by:	JF
Revisions	2/3/2016
Proposed Site Plan	
2 of 2	
Project No.	15-02-01