

ADVERTISING AUTHORITY

This form must be completed and approved by the City Finance Office prior to presenting items to the City Council and/or Committees of the City Council. This covers all items which require formal bids, currently anything over \$25,000 (except emergency and repair costs)

I. PROJECT NO.: PR08-6001 CIP No. N/A
 II. PROJECT NAME: Halley Park Electrical Installation
 III. Project/Item(s) Description: To furnish and install electrical outlets throughout the park.

IV. BID LETTING DATE: September 9, 2008

V. ESTIMATED COST OF PROJECT/ITEM(S) \$ 40,000.00

VI. BASIS OF PAYMENT Assessed Non-Assessed
 Single Payment Partial Payment

VII. APPROPRIATION DATA

Amount	45,907			
Fund	505			
Department	8912			
Line Item	4372			

VIII. (If applicable) Grant No.: N/A
 Funding Source: Parks & Rec CIP
 Estimated Completion Date: November 5, 2008
 Estimated Grant Receipt Date: N/A


IX. DEPARTMENT/DIVISION:

Project Manager: Randy Lyons Date 8/4/08

DIVISION MANAGER Signature _____ Date _____

DEPARTMENT DIRECTOR Signature [Signature] Date 8.4.08

FINANCE OFFICE USE ONLY			Approved		Carbon Copy
	Date	Initial	Yes	No	
Appropriation	8/4/08	RL	<input checked="" type="checkbox"/>	<input type="checkbox"/>	Investment Desk
Cash Flow			<input type="checkbox"/>	<input type="checkbox"/>	Public Works
			<input type="checkbox"/>	<input type="checkbox"/>	Engineering
			<input type="checkbox"/>	<input type="checkbox"/>	Project Manager

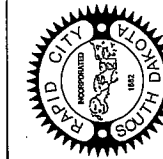


WPE
 WEST PLAINS ENGINEERING, INC
 RAPID CITY, SOUTH DAKOTA
 (605) 348-7455

Halley Park

Holiday Lighting Power


CITY OF RAPID CITY PROJECT NO. PR08-6001

**PROJECT
 LOCATION**

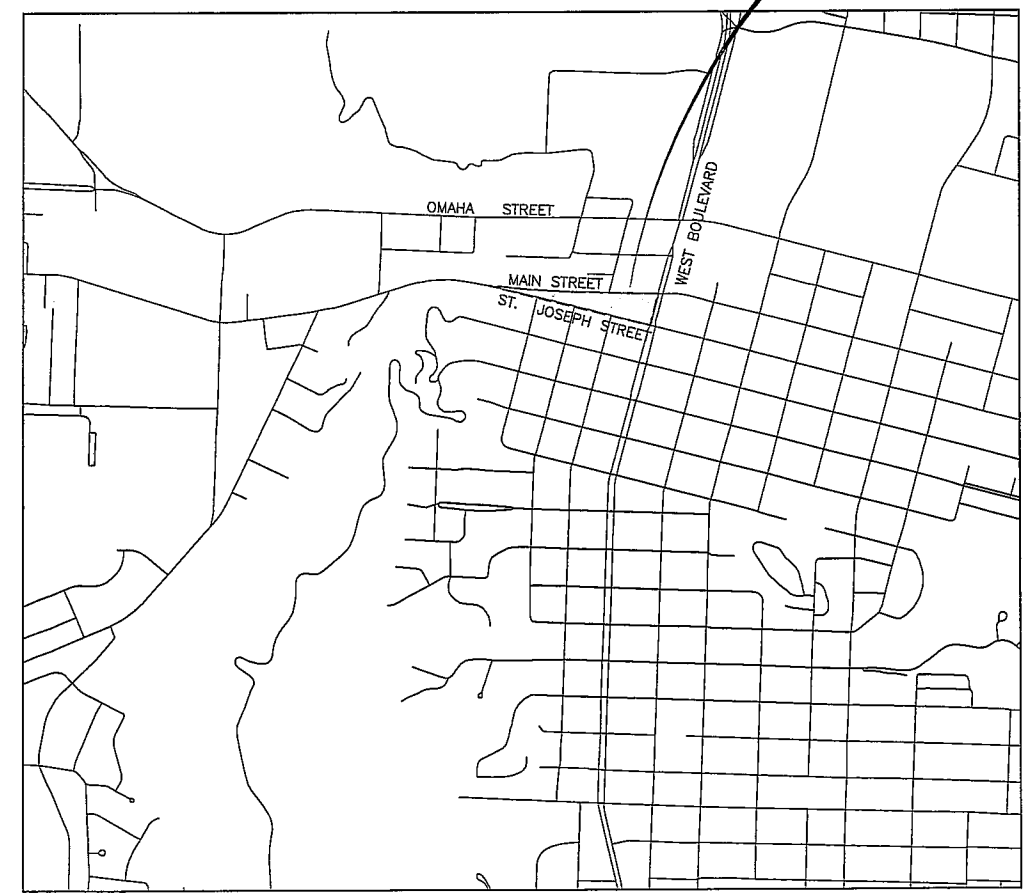

INDEX OF SHEETS

- 1 COVER SHEET
- 2 SITE PLAN
- 3 DETAILS


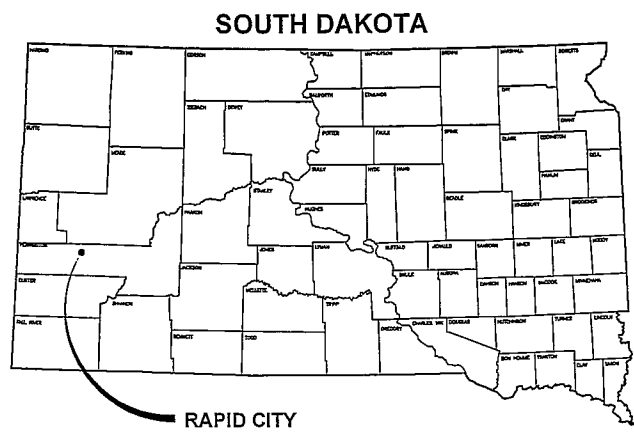


PROJECT LOCATION MAP NOT TO SCALE

Plan Set Number :



Halley Park
Holiday Lighting Power
 CITY OF RAPID CITY PROJECT NO. PR08-6001

ONE CALL
 BEFORE DIGGING
 1-800-781-7474

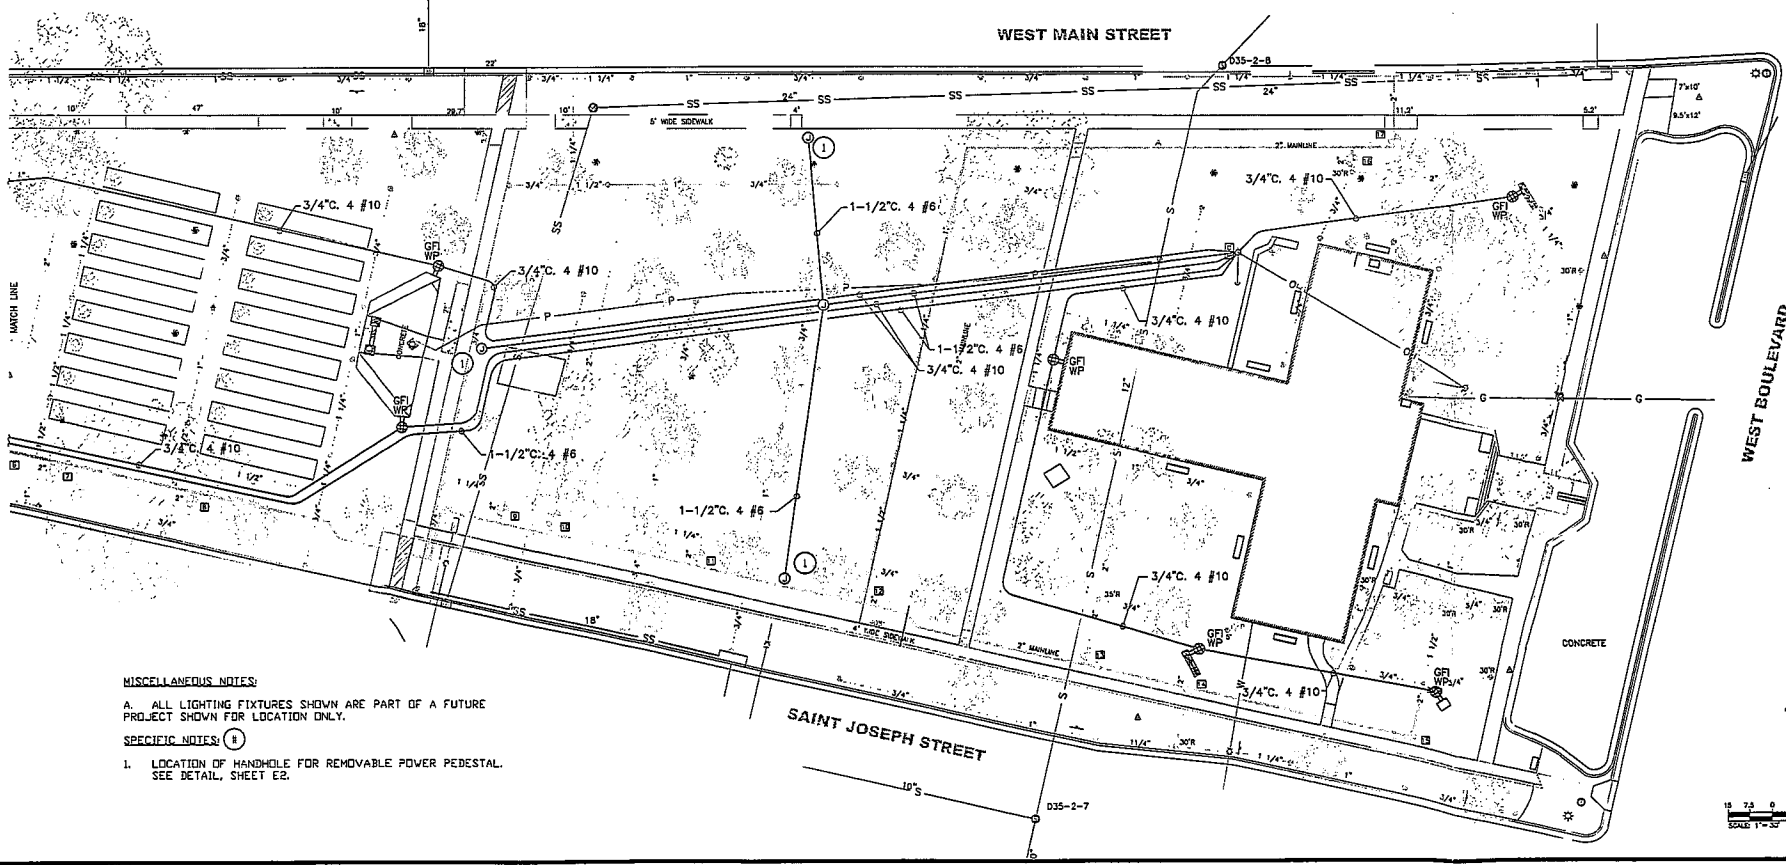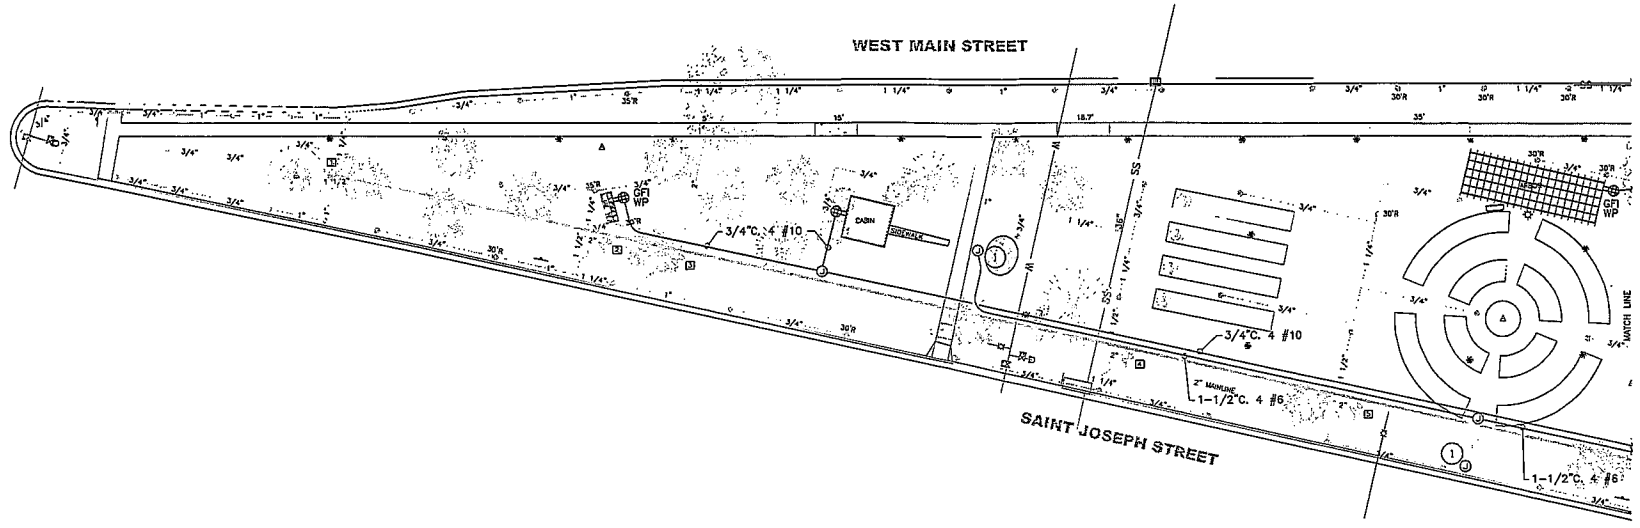

MISCELLANEOUS NOTES:
 A. ALL LIGHTING FIXTURES SHOWN ARE PART OF A FUTURE PROJECT SHOWN FOR LOCATION ONLY.

SPECIFIC NOTES: ①
 1. LOCATION OF HANDHOLE FOR REMOVABLE POWER PEDESTAL. SEE DETAIL, SHEET E2.

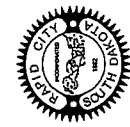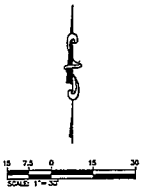

WPE WEST ENGINEERING, INC.
 PROFESSIONAL ENGINEERS
 1000 S. GARDEN ST. SUITE 200
 RAPID CITY, SD 57701
 PHONE: (605) 342-8442
 FAX: (605) 342-8442
 WWW: www.westengineering.com

Prepared By:

Scale: 1" = 30'

Designed By:	Drawn By:
RWT	VLS
Design Date:	Print Date:
07/2008	07/2008
Internal Job No:	
WPE#R08044	
Surveyed By:	Survey Date:
RG/SS	
Revisions:	

HALLEY PARK
 HOLIDAY LIGHTING POWER

CITY OF RAPID CITY: PR08-1588

Sheet Title:

ELECTRICAL

SITE PLAN

Sheet:

E1 of 2